

Date: 17-Jul-25
Quotation No: 0311-07-25
PR No. 0725.052

REQUEST FOR PROPOSAL

Company Name

Address

Please quote your lowest price on the item/s listed below, stating the shortest time of delivery and submit your quotation duly signed by your representative not later than _____.


ANSON M. TAGTAG
Chairperson, Bids and Awards Committee

- NOTES:
1. ALL ENTRIES MUST BE TYPEWRITTEN OR PRINTED LEGIBLY.
 2. DELIVERY PERIOD IS WITHIN **15** CALENDAR DAYS.
 3. WARRANTY SHALL BE FOR A PERIOD OF **SIX (6) MONTHS** FOR SUPPLIES & MATERIALS/**ONE (1) YEAR** FOR EQUIPMENT, FROM DATE OF ACCEPTANCE BY THE PROCURING ENTITY.
 4. PRICE VALIDITY SHALL BE VALID FOR A PERIOD OF **30** CALENDAR DAYS.
 5. PHIL-GEPS REGISTRATION CERTIFICATE SHALL BE ATTACHED UPON SUBMISSION OF THE QUOTATION.
 6. BIDDERS SHALL SUBMIT ORIGINAL BROCHURES SHOWING CERTIFICATIONS OF THE PRODUCT BEING OFFERED.

Title of Procurement:

Detailed Engineering Design for three (3) DENR Marine Scientific Research Stations (MSRS) in Aparri (Cagayan), Casiguran (Aurora) and Alabel (Sarangani)

Purpose:

For official use of DENR BMB-MSRS

Approved Budget for the Contract (ABC):

₱1,200,000.00

ITEM NO.	ITEMS/DESCRIPTIONS	QTY./ UNIT	UNIT PRICE	TOTAL PRICE
1	Detailed Engineering Design for three (3) DENR Marine Scientific Research Stations (MSRS) in Aparri (Cagayan), Casiguran (Aurora) and Alabel (Sarangani) <i>Please see attached Terms of Reference (TOR and ARCHITECTURAL DESIGN)</i> Additional Requests from Procuring Entity: ☒ Please provide sample upon request of end-user ☒ Please see full specifications/attached sample design for reference. ☒ Other conditions to this request, please state: For more info, please contact the end-user at 0953-760-1979 / 8924-6031 loc. 201 Kindly address all proposals to the Chairperson, Bids and Awards Committee Contract shall be awarded to the bidder per: ☐ Item basis ☒ Lot basis Bidders must submit the following requirements upon submission of proposal. Non-submission of these requirements shall be grounds for disqualification from the bidding process: 1. DTI/SEC Registration Certificate 2. Valid and Current Mayor's Permit 3. PHILGEPS Certificate of Registration 4. BIR Certificate of Registration 5. Sign Omnibus Sworn Statement 6. Income Tax Return (ITR) Important Note: -For goods, conforme of the winning bidder must be done within seven (7) calendar days upon serving of the PO. -For services, conforme of the winning bidder must be done within fourteen (14) calendar days upon serving of the JO. -Notarization of the OSS should be complied with after the award of the contract but before payment pursuant to Item 6.3 of GPPB 09-2020	1 lot	P _____	P _____

Brand : _____
Delivery Period : _____
Warranty : _____
Price Validity : _____

After having carefully read and accepted your Request for Quotation, I/We quote you on the item at prices noted above.

Printed Name/Signature

Tel. No./Cellphone No.

Email Address

Date

TERMS OF REFERENCE

A FIRM TO DEVELOP THE DETAILED ENGINEERING DESIGN FOR THREE (3) DENR MARINE SCIENTIFIC RESEARCH STATIONS IN APARRI (CAGAYAN), CASIGURAN (AURORA), AND ALABEL (SARANGANI)

I. BACKGROUND AND INTRODUCTION

The Department of Environment and Natural Resources (DENR) Marine Scientific Research Station (MSRS) aims to support a wide range of scientific research activities and monitor the coastal and marine environment, providing facilities that enable evidence-based conservation and policy development. Its modular, standardized architectural designs developed by Jorge Yulo Architects and Associates (JYAA) allows for flexible construction and future expansion while considering site-specific factors such as lot size and climate.

The DENR intends to engage the technical and professional expertise of a local design-build firm to undertake the detailed engineering design of essential mechanical, electrical (data conduit), fire protection, and plumbing/sanitary, and structural engineering design for the DENR MSRS.

II. OBJECTIVE

To develop the respective Bill of Quantities, Detailed Cost Estimates and Detailed Engineering Design, including Structural, Mechanical, Electrical, Fire Protection and Plumbing/Sanitary Design/Plan for the DENR Marine Scientific Research Stations in Aparri (Cagayan), Casiguran (Aurora), Alabel (Sarangani), based on the approved Architectural Designs and perspectives provided to the DENR by Jorge Yulo Architects & Associates (JYAA).

III. SCOPE OF WORK

This engagement shall cover the development of the Bill of Quantities, Detailed Cost Estimates, and Detailed Engineering Designs, namely the Mechanical, Electrical, Fire Protection, Plumbing/Sanitary And Structural Engineering Design based on the Architectural Design Specific for each of the DENR MSR Stations in the following areas:

A. DENR MSR Station sites with Architectural Designs from DENR-JYAA:

- 1. Aparri, Cagayan;**

2. **Casiguran, Aurora;**
3. **Alabel, Sarangani Province;**

B. Technical Specifications of services required. The DENR BMB requires the services of a Firm for the following:

1. **Design Services for each of the DENR MSR Station sites in Item III. A. above.**
 - a) Structural Design Services
 - b) Mechanical Design Services, including Heating, Ventilation and Air Conditioning
 - c) Electrical Design Services
 - d) Fire Protection Design Services
 - e) Plumbing / Sanitary Design Services
 - f) Electronic (Auxiliary) Design Services
 - g) Technical Specifications
 - h) Bill of Quantities (Detailed Cost Estimate)

C. Obligations of the Winning Bidder/Contractor

1. Render engineering design services necessary for the implementation of the Project. The engineering design services shall include, but shall not be limited to, design for structural, electrical, mechanical, sanitary/plumbing, fire protection and electronics. All plans/drawings shall be generated using licensed AutoCAD or Revit software and printed on a 20inch x 30inch High-quality Blueprints; and,
2. Undertake Detailed Engineering Designs (DEDs) and provide detailed cost estimates, bill of quantities, using the given data such as Architectural Designs/Plans provided by the End-User.

D. Obligations of the BMB

1. Provide full information available on all requirements for the Project including Architectural Design/Plan;

An Architectural Design/Plan will be provided by the End-User in collaboration with Jorge Yulo Architects & Associates. However, this design shall serve as reference only. The winning bidder is responsible for the accuracy and applicability of all data, and coordination and collaboration with the Architectural Team from JYAA, through the End-User. The Architectural Design/Plan is hereto attached as Annex "A" respectively;

2. Approve the Winning Bidder or Contractor's designs without diminishing their full and sole responsibility for the quality and integrity thereof;
3. Give prompt written notice thereof to Winning Bidder or Contractor, if it observes or becomes aware of any defect in the design services provided;
4. Designate, when necessary, representatives authorized to act on its behalf. It shall examine documents submitted by the Winning Bidder or Contractor and render decisions pertaining thereto promptly, to avoid unreasonable delay in the progress of their work. It shall observe the procedure of issuing orders to the Winning Bidder or Contractor;
5. Compensate the accomplishment accepted in the conformance with the submitted approved deliverables under the Design Contract.

IV. DELIVERABLES

Physical outputs, submissions, and other services for each of the DENR MSR Station sites in Item III. A. above:

A. Work Schedule for the engagement of consultancy services.

B. Three (3) sets of signed and sealed plans of the above-mentioned design services for each MSR Station printed in 20"x30" size blueprints, and one (1) set consisting of plans printed in 20"x30" in normal paper for each MSR Station:

1. Aparri, Cagayan
2. Casiguran, Aurora
3. Alabel, Sarangani

A total of nine (9) sets of signed and sealed plans in blueprint and three (3) sets of plans on normal paper.

C. Three (3) sets of signed and sealed Scope of Works and Technical Specifications of the above-mentioned design services of each MSR Station Sites printed in A4 size sheets.

A total of nine (9) sets of signed and sealed Scope of Works and Technical Specifications for all MSR Stations.

- D. Three (3) sets of signed and sealed Bill of Quantities and Detailed Cost Estimates for each design plan of the above-mentioned MSR Stations Sites printed in A4 size sheets.

A Total of Nine (9) sets of signed and sealed Bill of Quantities and Detailed Cost Estimates;

- E. Three (3) sets of signed and sealed Structural Design Analysis of each Structural plans of the above-mentioned MSR Station Sites printed in A4 size sheets; Total of Nine (9) sets of Structural Design Analysis;

- F. Three (3) sets of Gantt Chart/S-Curve or PERT/CPM of each design plans of the above-mentioned MSR Station Sites printed on any size sheet; Total of Nine (9) sets of Gantt Chart/S-Curve or PERT/CPM; and,

- G. Electronic PDF copy of the design plans, Scope of Works and Technical Specifications, Bill of Quantities and Detailed Cost Estimates, Structural Design Analysis, and Gantt Chart/S-Curve or PERT/CPM of each above-mentioned MSR Station Sites.

All deliverables shall be submitted for review, approval, and acceptance of the end-user.

V. TIMELINE

The Firm's contract period for undertaking the detailed engineering designs shall not be more than fifteen (15) days, and the Design Firm shall commence work upon receipt of Notice to Proceed.

VI. Other Requirements to be Submitted by Prospective Bidders for Bidding Purposes Shall Include the Following as Required by the End-User

- A. Organizational Chart for the development of Detailed Engineering Design;
- B. Company profile and on-going/completed design projects, and details of at least three (3) technically relevant projects with certificates of acceptance;
- C. The key professionals and the respective qualification of the design personnel shall be as follows:
 - 1. **Structural Engineer.** The Structural Engineer must be a duly-licensed Civil Engineer with at least three (3) years'

experiences in structural design and shall preferably be knowledgeable in the application of rapid construction technologies.

2. **Professional Electrical Engineer.** The Electrical Engineer must be a registered Professional Electrical Engineer with at least three (3) years' experiences in the design of lighting, power distribution system and preferably knowledgeable in developments in emergent efficient lighting technologies and energy management.
3. **Professional Mechanical Engineer.** The Mechanical Engineer must be a Professional Mechanical Engineer with at least three (3) years' experiences in machineries with regards to fixtures, roughing-ins and Heating, Ventilation and Air Conditioning, and preferably knowledgeable in emergent, alternative energy-efficient technology.
4. **Sanitary Engineer.** The Sanitary Engineer must be a duly-licensed Sanitary Engineer with at least three (3) years' experiences in the design of water supply and distribution, plumbing, and preferably knowledgeable in waste water management/treatment.

*The key professionals listed above are required. **The DESIGN CONTRACTOR** may, as needed and its own expense, add additional professionals and/or support personnel for the optimal performance of all Engineering Design Services, as stipulated in these Terms of Reference, for the PROJECT. Prospective bidders shall attach the resume and photocopy of PRC license with signatures of the above listed required key professionals.*

VII. ELIGIBILITY

The Firm must have:

- A. At least three (3) years of extensive experience in design and construction with similar projects.
- B. A proven track record of completing projects within the agreed timeline and budget.
- C. A commitment to safety, sustainability, and ethical construction practices.

- D. Adequate resources and financial contracting capacity, including personnel and equipment, to handle a project of this scale.
- E. Registered with the Philippine Government Electronic Procurement System (PhilGEPS - Platinum).

VIII. TERMS OF PAYMENT

The total contract for the services shall amount to PHP 1,200,000.00 (*inclusive of 15% withholding tax expanded + 5% Final VAT*) and shall follow the payment schedule below:

PAYMENT TRANCHES	AMOUNT (PHP)	PARTICULARS
30%	360,000.00	Upon signing of contract, submission of the work schedule and approval by the DENR BMB.
70%	840,000.00	Upon submission of Deliverables (Section IV. above), and acceptance by DENR BMB in coordination with JYAA.
100%	1,200,000.00	TOTAL

The documents for submission are:

1. Company/firm profile detailing experience and previously completed projects similar to the scope of work, detailed task, and deliverables of this project;
2. List of all previous and on-going engagement/projects of the firm indicating the accomplishment status;
3. Curriculum vitae of all members which includes the following:
 - a. Educational background
 - b. Relevant work experiences to the role/assignment in the team
4. Sample of the completed works of the firm related to the ecosystem valuation and each of the team member in electronic copy (or URL if published)
5. PhilGEPS Platinum Registration
6. BIR Certificate of Registration
7. Omnibus Sworn Statement
8. Income Tax Return

Incomplete/non-submission of these requirements shall be grounds for disqualification from the procurement process

Please send application not later than _____ to:

THE CHAIRPERSON

Bids and Awards Committee
Biodiversity Management Bureau
Ninoy Aquino Parks and Wildlife Center
Quezon Ave., Diliman, Quezon City
(02) 8-924-6031 loc. 221
Email: bacsec@bmb.gov.ph

Approved by:



ATTY. ERNESTO D. ADOBO JR., CESO I
Undersecretary for Legal and Administration
and Supervising Undersecretary of the BMB



Department of Environment and Natural Resources

(ANNEX A)

ARCHITECTURAL DESIGNS

MARINE SCIENTIFIC RESEARCH STATIONS



Department of Environment and Natural Resources

ARCHITECTURAL DESIGN

APARRI, CAGAYAN

MARINE SCIENTIFIC RESEARCH STATION



TABLE OF CONTENTS		REPUBLIC OF THE PHILIPPINES DEPARTMENT OF PUBLIC WORKS AND HIGHWAYS OFFICE OF THE BUILDING OFFICIAL	
ARCHITECTURAL	ELECTRICAL	LAND USE/ZONING	
CS-1 PERSPECTIVES VICINITY MAP SITE LOCATION MAP SITE DEVT PLAN A-1 BLOW-UP SITE DEVT PLAN A-2 FLOOR PLAN A-3 ROOF PLAN A-4 ELEVATIONS A-5 SECTIONS A-6 REFLECTED CEILING PLAN A-7 DOORS AND WINDOWS SCHEDULE A-7a DOORS AND WINDOWS SCHEDULE A-7b WINDOWS SCHEDULE, WIND DEFLECTOR, WINDOW SHUTTER DETAILS A-8 RAMP AND STAIR DETAILS A-9 GUARD HOUSE, PUMP ROOM, GENSSET ROOM DETAILS		LINE AND GRADE	
STRUCTURAL	MECHANICAL	ARCHITECTURAL	
		STRUCTURAL	
		SANITARY	
		ELECTRICAL	
		MECHANICAL	

**JORGE YULO
ARCHITECTS & ASSOCIATES**

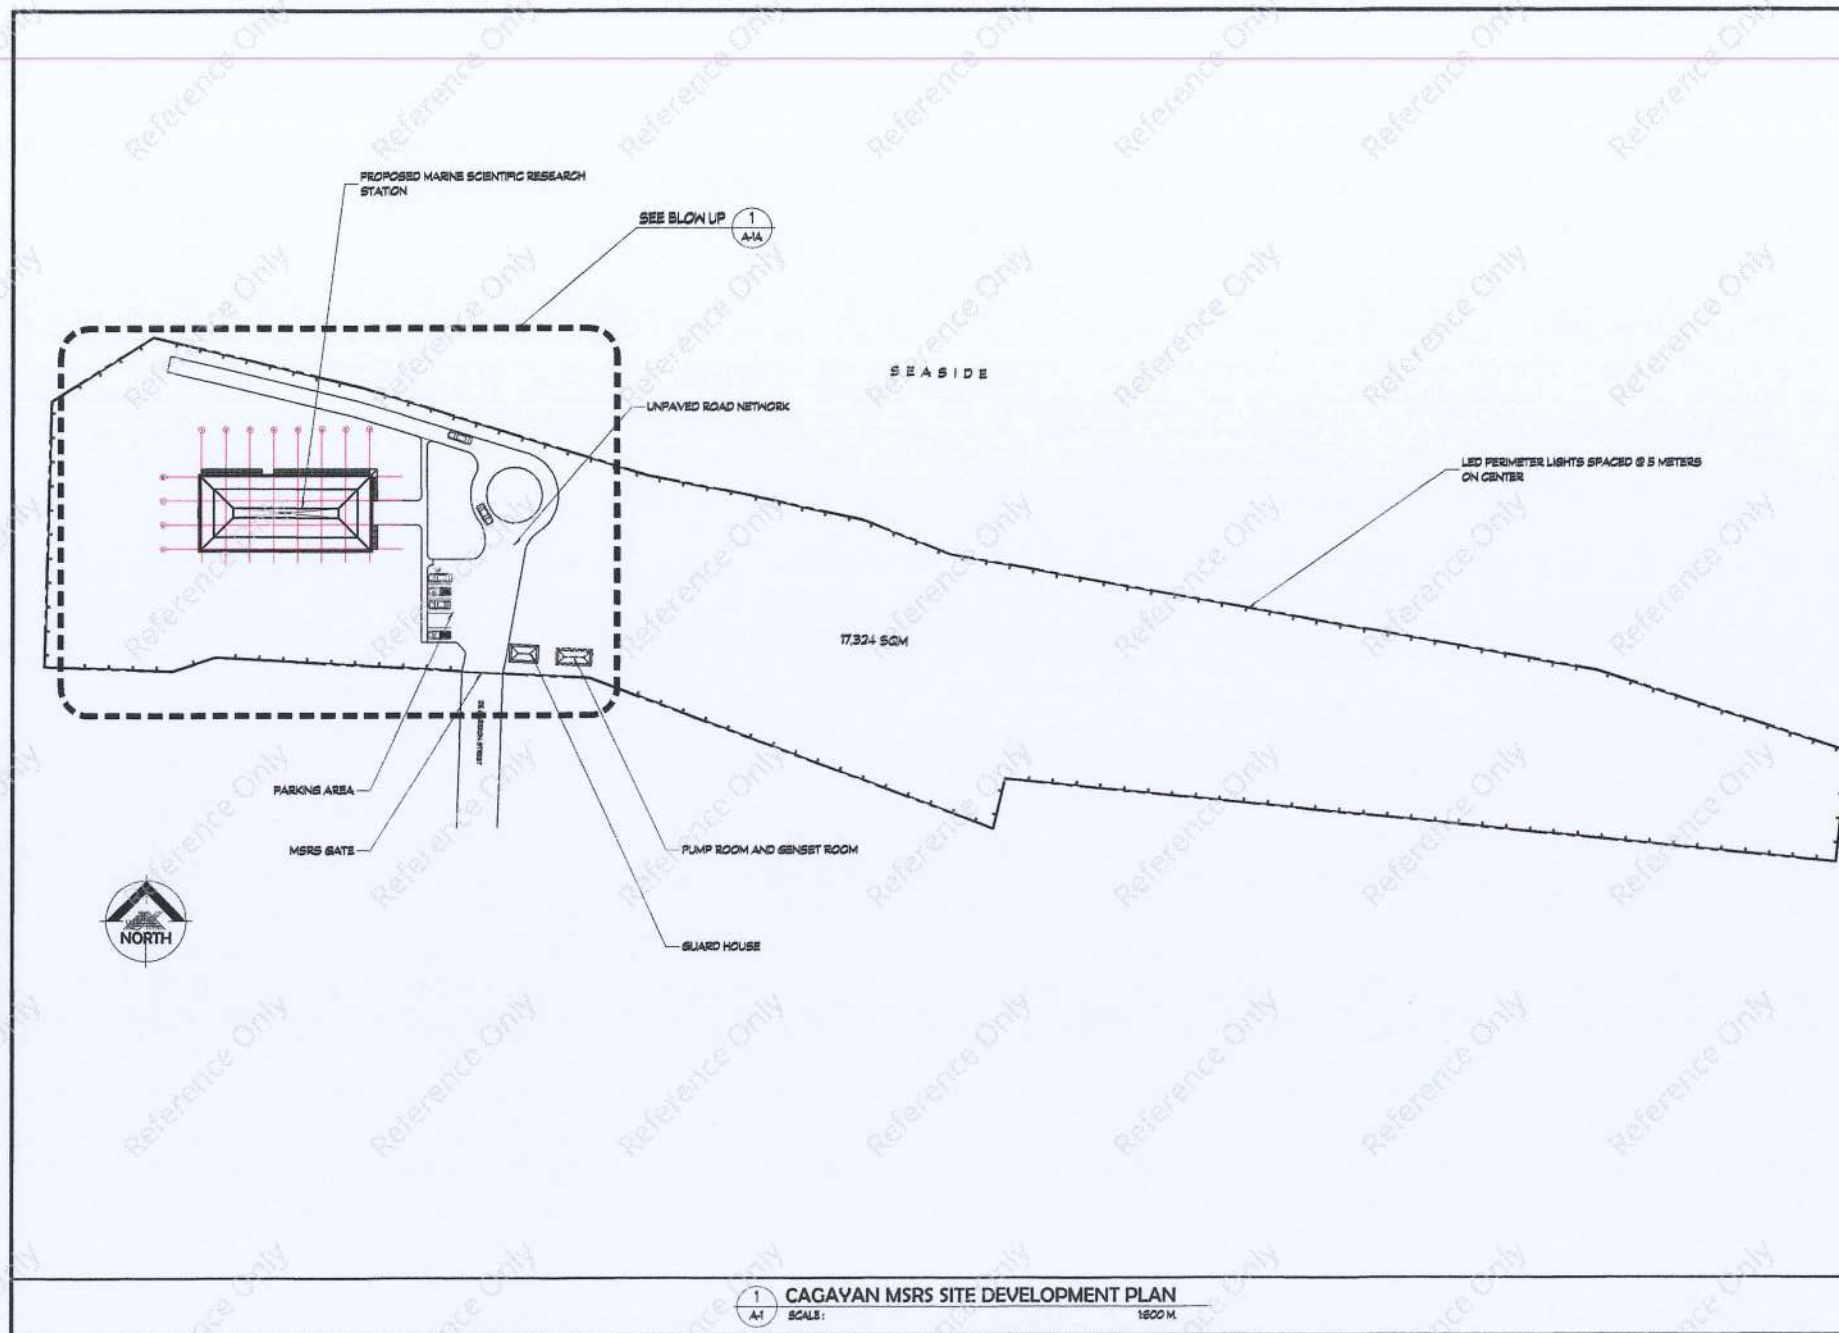
3F Automata Center, 2030 Don
Olivero Street, Avenue Extension,
Makati City, Philippines 1302
Telephone No. (02) 885074
885074
885074
Facile:
Email Address:
URL Address:
www.jorgeyulo.com

PTF NO. 10475571	REG. NO. 12396
ISSUED ON: JAN. 08, 2025	TIN NO. 102-325-935
STUDIED AT: MAKATI CITY	
JORGE MANUEL B. YULO ARCHITECT	

ENGINEER
PTF NO. REG. NO.
ISSUED ON: TIN NO.
ISSUED AT:

PROJECT TITLE: PROPOSED MARINE SCIENTIFIC RESEARCH STATION
LOCATION: BRGY. PUNTA, APARRI, CAGAYAN, PHILIPPINES
OWNER: MR. JOSELITO D. RAZON

SHEET CONTENTS: PERSPECTIVES VICINITY MAP LOCATION MAP
DATE: MARCH 2025
DRAWN BY: BT
CHECKED BY: PPA
GRAPHIC SCALE: 1:100 METERS 1:500 METERS 1:1000 METERS 1:2000 METERS 1:5000 METERS
SHEET NO.: CS-1



JORGE YULO ARCHITECTS & ASSOCIATES

3rd Floor, Asean Building, 2nd Ave. East, 22nd Street, Cebu City, Philippines 6000
 Telephone No. (032) 8452734
 Fax No. (032) 8452734

Email Address:
 jayulo@jorgeyulo.com.ph
 jayulo@jorgeyulo.com.ph
 URL: www.jorgeyulo.com

PTR NO.: 10475571	REG. NO.: 12396
ISSUED ON: JAN 08, 2025	TIN NO.: 102-325-935
ISSUED AT: MARIKINA CITY	

JORGE MANUEL B. YULO
ARCHITECT

ENGINEER	
PTR NO.:	REG. NO.:
ISSUED ON:	TIN NO.:
ISSUED AT:	

PROJECT TITLE:
PROPOSED MARINE SCIENTIFIC RESEARCH STATION

LOCATION:
BRGY. PUNTA APARRI, CAGAYAN, PHILIPPINES

OWNER:
MR. JOSELITO D. RAZON

SHEET CONTENTS:
SITE DEVELOPMENT PLAN

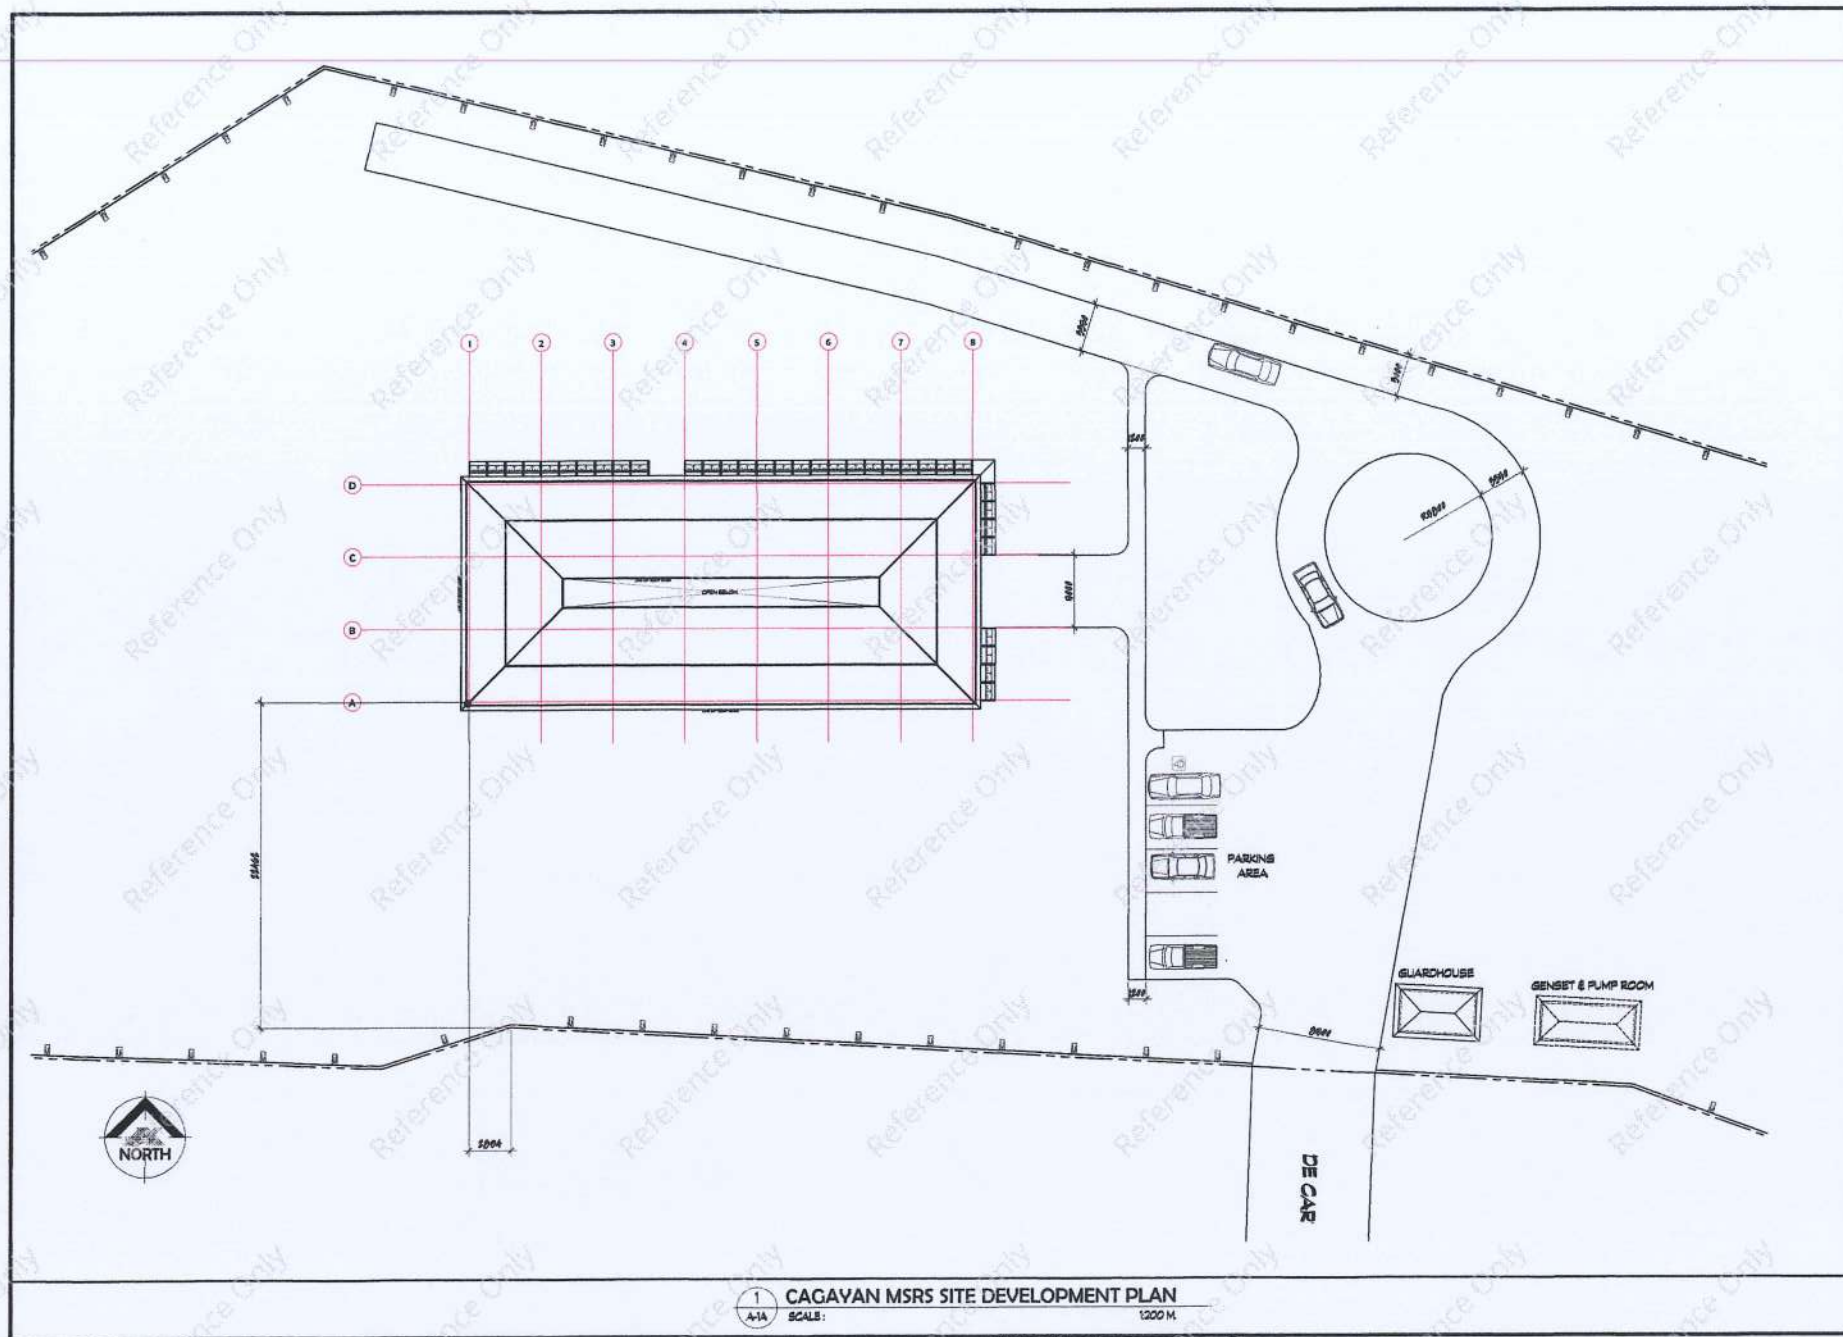
DATE:
MARCH 2025

DRAWN BY: STL

CHECKED BY: PFRAS

GRAPHIC SCALE:
 1:50 METERS
 1:100 METERS
 1:200 METERS
 1:500 METERS
 1:1000 METERS

SHEET NO.:
A-1



**JORGE YULO
ARCHITECTS & ASSOCIATES**

3rd Floor Automatic Center Bldg.
2257 Don Chino Rocas Ave. Extn.
Makati City, Philippines 1211
Telephone Nos. (832) 6452164
6452174
6452174
Fax No. (832) 6452174
Email Address:
jyulo@jyulo.com
jyulo.associates@jyulo.com
URL Address:
http://www.jyulo.com

PTR NO.:	REG. NO.:
10475571	12396
ISSUED ON:	TIN NO.:
JAN 08, 2025	102-325-935

ISSUED AT:
MAKATI CITY

JORGE MANUEL B. YULO
ARCHITECT

ENGINEER

PTR NO.:	REG. NO.:
ISSUED ON:	TIN NO.:

ISSUED AT:

PROJECT TITLE:
**PROPOSED
MARINE SCIENTIFIC
RESEARCH
STATION**

LOCATION:
BRGY. PUNTA
APARRI, CAGAYAN,
PHILIPPINES

OWNER:
MR. JOSELITO D. RAZON

SHEET CONTENTS:
**SITE
DEVELOPMENT
PLAN**

DATE:
MARCH 2025
DRAWN BY:
STL

CHECKED BY:
PPAB

GRAPHIC SCALE:
1:20 METERS
1:50 METERS
1:100 METERS
1:200 METERS
1:500 METERS
1:1000 METERS

SHEET NO.:

A-1A

JORGE YULO ARCHITECTS & ASSOCIATES

3rd Floor Automatic Center Bldg.
2207 Don Quirino Ave. Ext.
Marikina City, Philippines 1212
Telephone No. (02) 882054
Fax No. (02) 882074
Email Address: jyulo@jyulo.com
info@jyulo.com
URL Address: www.jyulo.com

PTR NO. 10475571	REG. NO. 12376
ISSUED ON: JAN 08, 2025	TIN NO. 102-325-935
LISTED AT: MANKATI CITY	
JORGE MANUEL B. YULO ARCHITECT	

ENGINEER	
PTR NO.	REG. NO.
ISSUED ON:	TIN NO.
LISTED AT:	

 
PROJECT TITLE:
PROPOSED MARINE SCIENTIFIC RESEARCH STATION

LOCATION:
BRGY. PUNTA, APARRI, CAGAYAN, PHILIPPINES


OWNER:
MR. JOSE LITO D. RAZON

SHEET CONTENTS:
PROPOSED CAGAYAN MSRS FLOOR PLAN

DATE: MARCH 2025
DRAWN BY: ETL
CHECKED BY: PFA3



SHEET NO.:
A-2

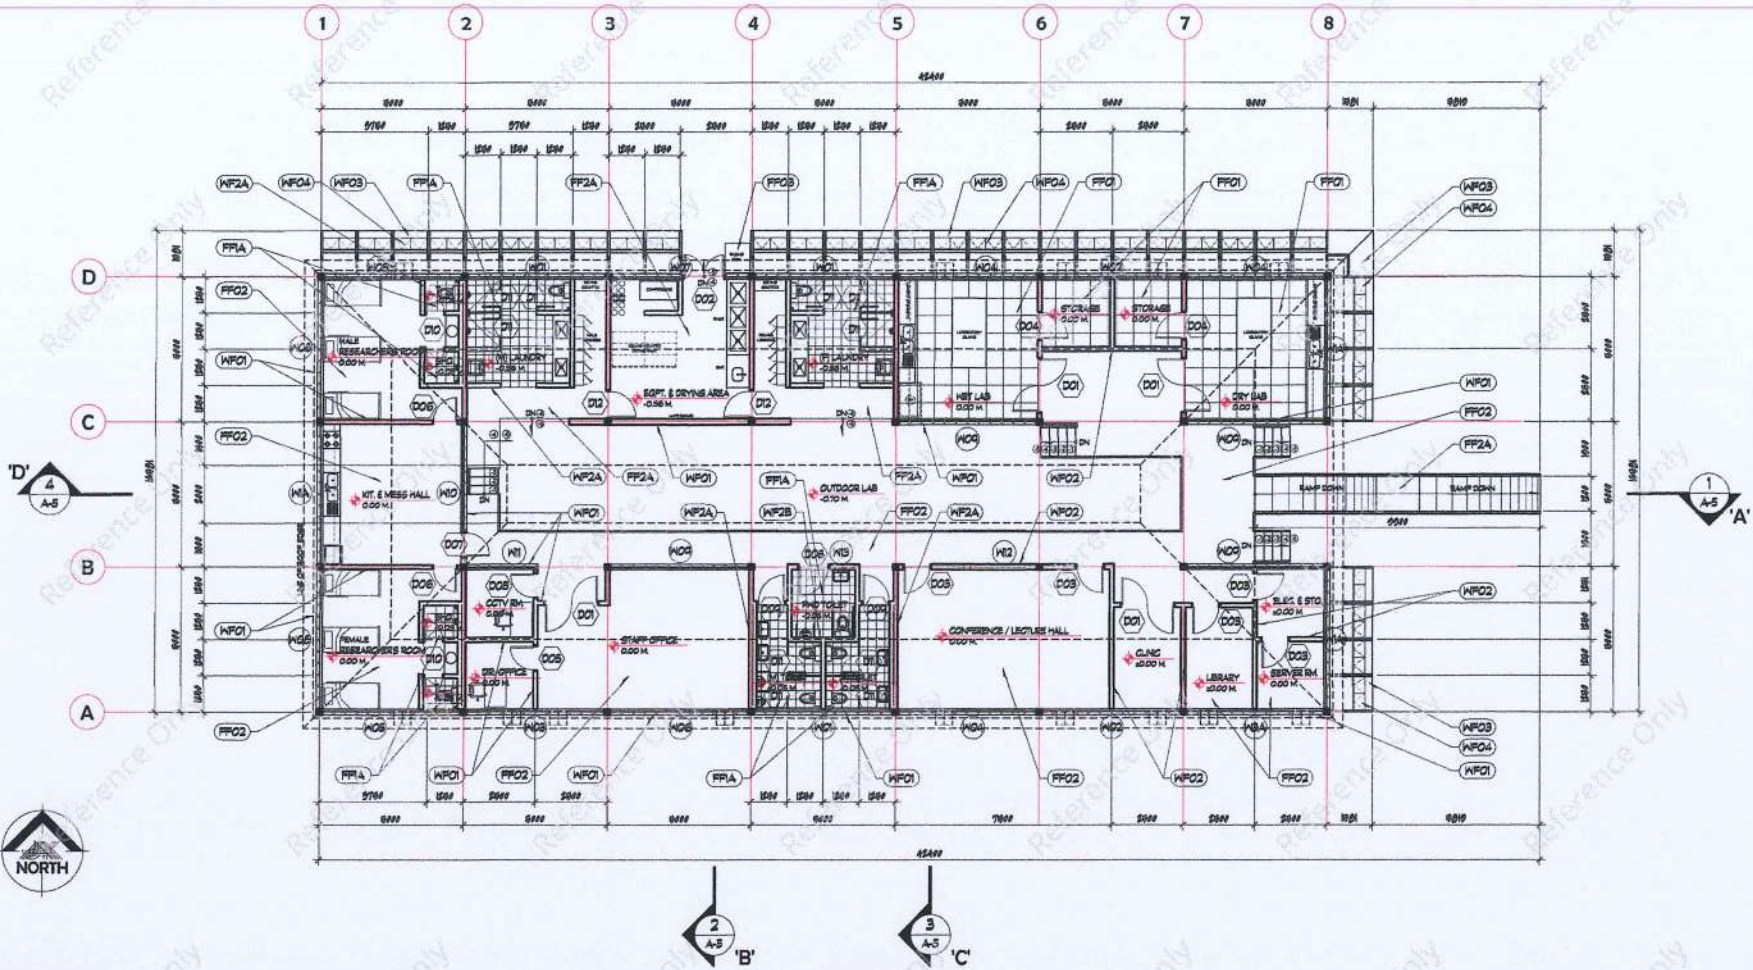


WALL FINISHES:

- (WF-01) 150 MM THK CONCRETE HOLLOW BLOCK WALL W/ 25 MM THK CEMENT PLASTER WITH 2 COATS OF CONCRETE SEALER, POLYURETHANE PAINT FINISH ON BOTH FACE.
- (WF-1A) 150 MM THK CONCRETE HOLLOW BLOCK WALL W/ 25 MM THK CEMENT PLASTER WITH 2 COATS OF CONCRETE SEALER, POLYURETHANE PAINT FINISH ON ONE FACE, TILE FINISH ON OTHER FACE (VERIFY TYPE).
- (WF-1B) 150 MM THK CONCRETE HOLLOW BLOCK WALL, TILE FINISH ON BOTH FACE (VERIFY TYPE).
- (WF-02) 100 MM THK CONCRETE HOLLOW BLOCK WALL W/ 25 MM THK CEMENT PLASTER WITH 2 COATS OF CONCRETE SEALER, POLYURETHANE PAINT FINISH ON BOTH FACE.
- (WF-2A) 100 MM THK CONCRETE HOLLOW BLOCK WALL W/ 25 MM THK CEMENT PLASTER WITH 2 COATS OF CONCRETE SEALER, POLYURETHANE PAINT FINISH ON ONE FACE, TILE FINISH ON OTHER FACE (VERIFY TYPE).
- (WF-2B) 100 MM THK CONCRETE HOLLOW BLOCK WALL, TILE FINISH ON BOTH FACE (VERIFY TYPE).
- (WF-03) 80 MM THK PRECAST CONCRETE WITH 2 COATS OF CONCRETE SEALER; POLYURETHANE PAINT FINISH
- (WF-04) ALUMINUM COMPOSITE PANEL ON METAL FRAME

FLOOR FINISHES:

- (FF-01) 600 MM X 600 MM HOMOGENOUS TILES FIN. (VERIFY TYPE)
- (FF-1A) 300 MM X 300 MM HOMOGENOUS TILES FIN. (VERIFY TYPE)
- (FF-02) SANDED TO SMOOTH PLAN GEMENT FINISH WITH CONCRETE SEALER & 3 COATS OF POLYURETHANE PAINT
- (FF-2A) PLAIN CEMENT CONCRETE FINISH
- (FF-03) 50MM THK RIVER STONE GRAVEL BED

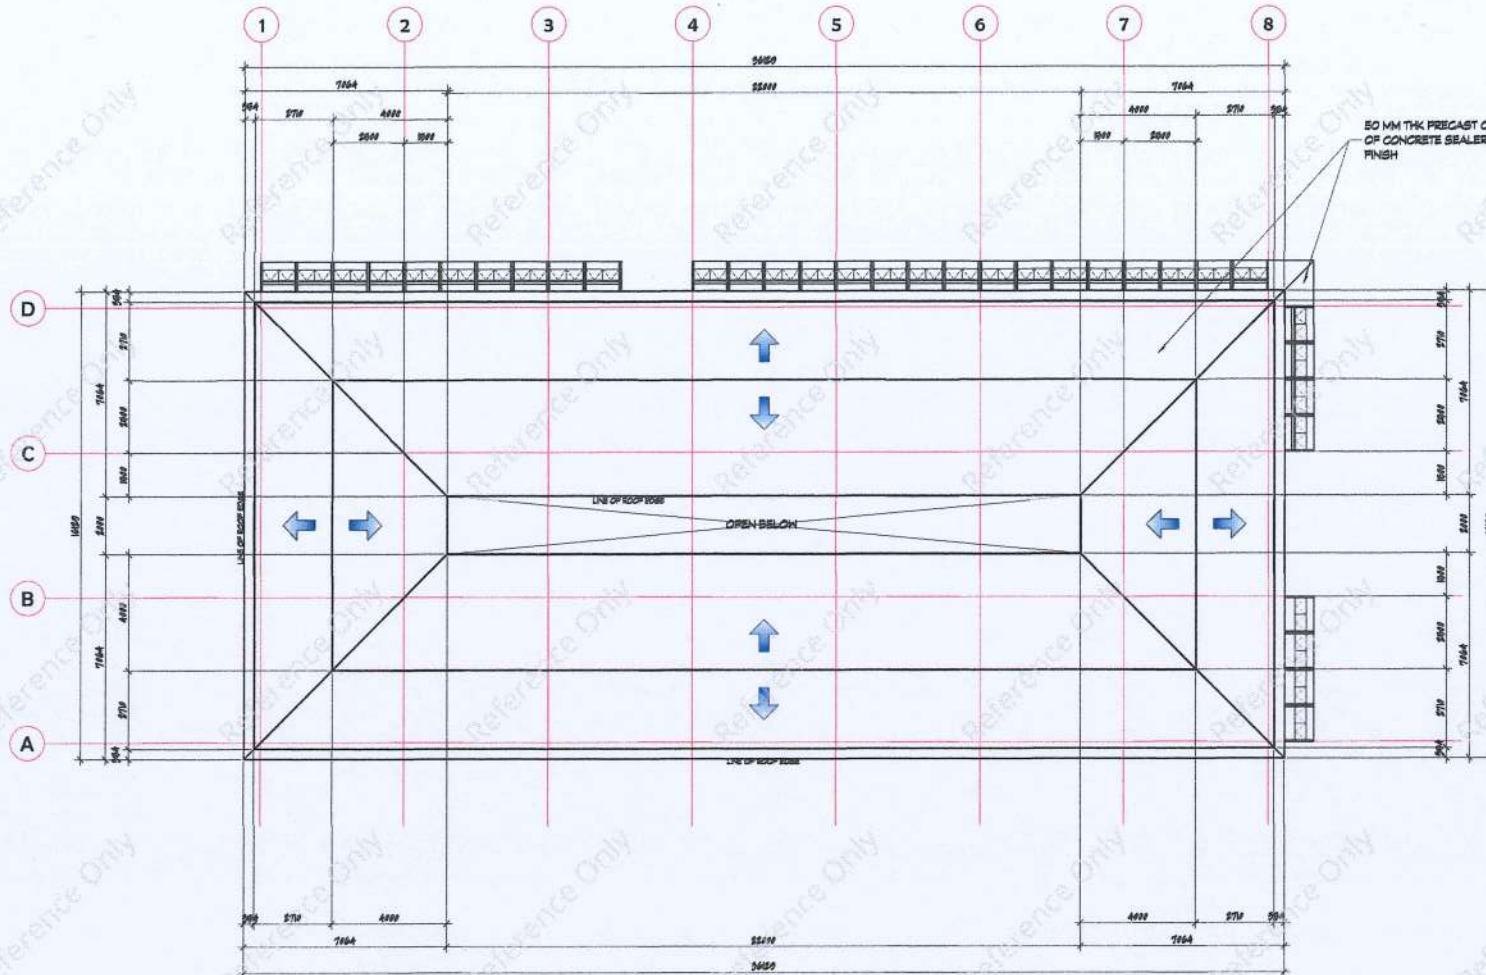1 PROPOSED CAGAYAN MSRS FLOOR PLAN
SCALE: 1:100 M



1 CAGAYAN MSRS ROOF PLAN
A-3 SCALE: 1/200 M.

MSRS_Cagayan_p.5

JORGE YULO ARCHITECTS & ASSOCIATES

3rd Floor Automatic Center Bldg.
2201 Don Chino Roa Ave. 6th Fl.
Alabang, C.A. Philippines 1231
Telephone Nos. (82) 8462584
8462574
Fax No. (82) 8462574
Email Address: jorgeyulo@jorgeyulo.com
jorge_yulo@yahoo.com
URL Address: http://www.jorgeyulo.com

PTR NO.: 10475571 REG. NO.: 12356
ISSUED ON: JAN 08, 2025 TIN NO.: 102-325-935
ISSUED AT: MAKATI CITY

JORGE MANUEL B. YULO
ARCHITECT

ENGINEER
PTR NO.: REG. NO.:
ISSUED ON: TIN NO.:
ISSUED AT:

PROJECT TITLE:
**PROPOSED
MARINE SCIENTIFIC
RESEARCH
STATION**

LOCATION:
BRGY. PUNTA
AFARRI, CAGAYAN,
PHILIPPINES

OWNER:
MR. JOSEITO D. RAZON

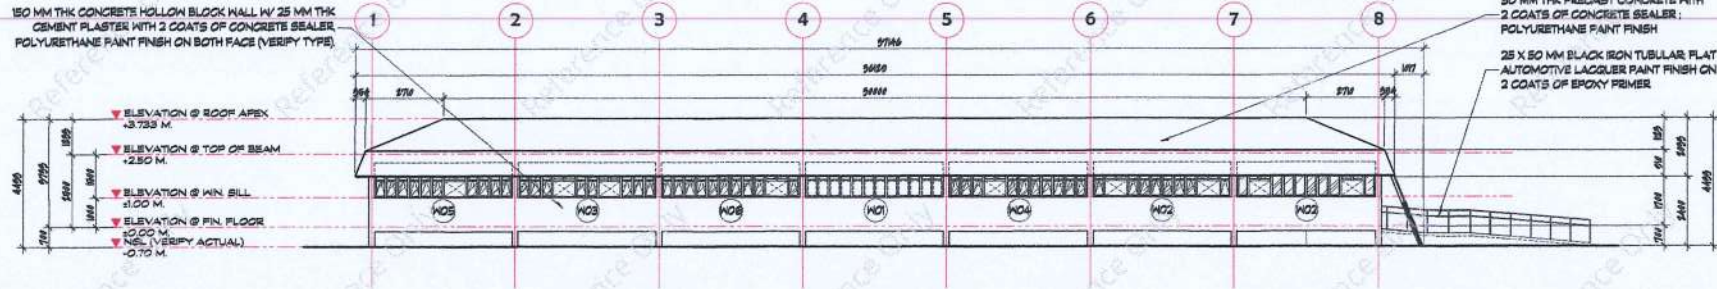
SHEET CONTENTS:
ROOF PLAN

DATE:
MARCH 2025
DRAWN BY: STL CHECKED BY: PFA3
GRAPHIC SCALE:
1:20 METERS
1:50 METERS
1:100 METERS
1:200 METERS
1:500 METERS
1:1000 METERS


SHEET NO.:
A-3

150 MM THK CONCRETE HOLLOW BLOCK WALL IV 25 MM THK CEMENT PLASTER WITH 2 COATS OF CONCRETE SEALER POLYURETHANE PAINT FINISH ON BOTH FACE (VERIFY TYPE)


▼ ELEVATION @ ROOF APEX
+3.733 M.
▼ ELEVATION @ TOP OF BEAM
+2.50 M.
▼ ELEVATION @ WIN. SILL
+1.00 M.
▼ ELEVATION @ FIN. FLOOR
+0.00 M.
▼ N.S.L. (VERIFY ACTUAL)
-0.70 M.




1 NORTH ELEVATION
SCALE: 1/200 M

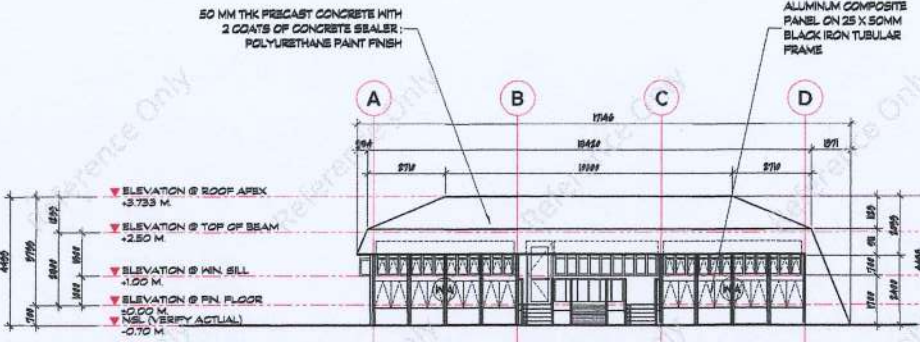

2 WEST ELEVATION
SCALE: 1/200 M

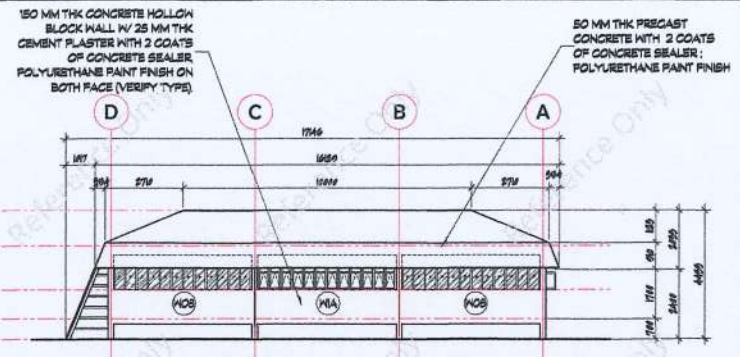

3 EAST ELEVATION
SCALE: 1/200 M

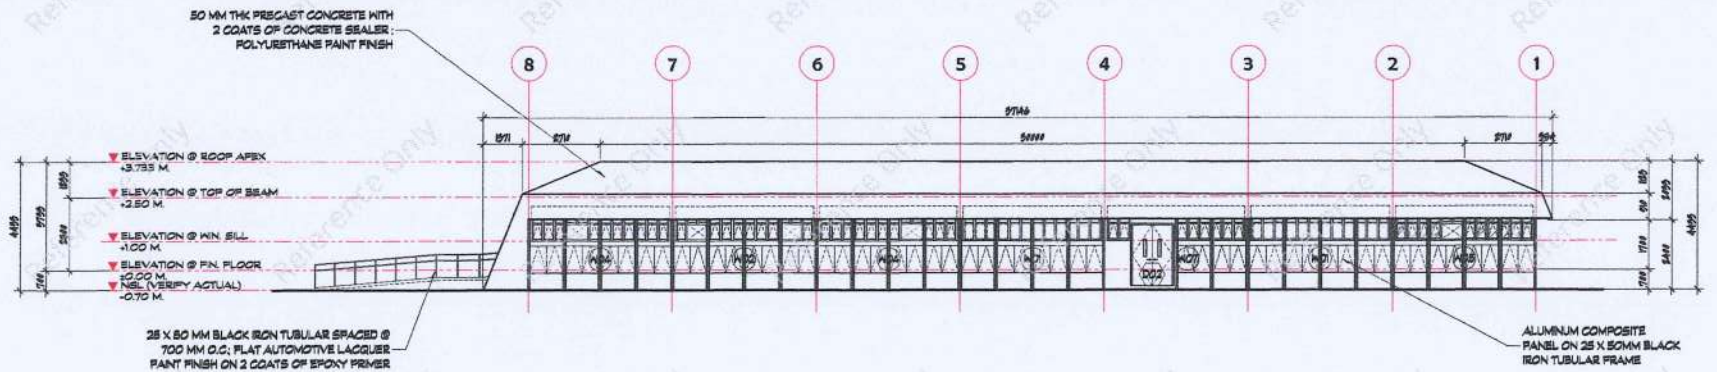

4 SOUTH ELEVATION
SCALE: 1/200 M

JORGE YULO ARCHITECTS & ASSOCIATES

3rd Floor, Asean Center Bldg.
227 Old China Road, 1st Flr.
Marikina City, Philippines 1201
Telephone No. (02) 8822344
Fax No. (02) 8822374
Email Address:
jorgeyulo@jorgeyulo.com
info.jorgeyulo@jorgeyulo.com
URL Address:
http://www.jorgeyulo.com

PTIR NO.: 10475571 REG. NO.: 12396
ISSUED ON: JAN 08, 2025 TEN NO.: 102-325-935

PROJECT AT:
MANKATI CITY

JORGE MANUEL B. YULO
ARCHITECT

ENGINEER

PTIR NO.: REG. NO.:
ISSUED ON: TEN NO.:
PROJECT AT:

PROJECT TITLE:
PROPOSED
MARINE SCIENTIFIC
RESEARCH
STATION

LOCATION:
BRGY. PUNTA,
APARRI, CAGAYAN,
PHILIPPINES

OWNER:
MR. JOSELO D. RAZON

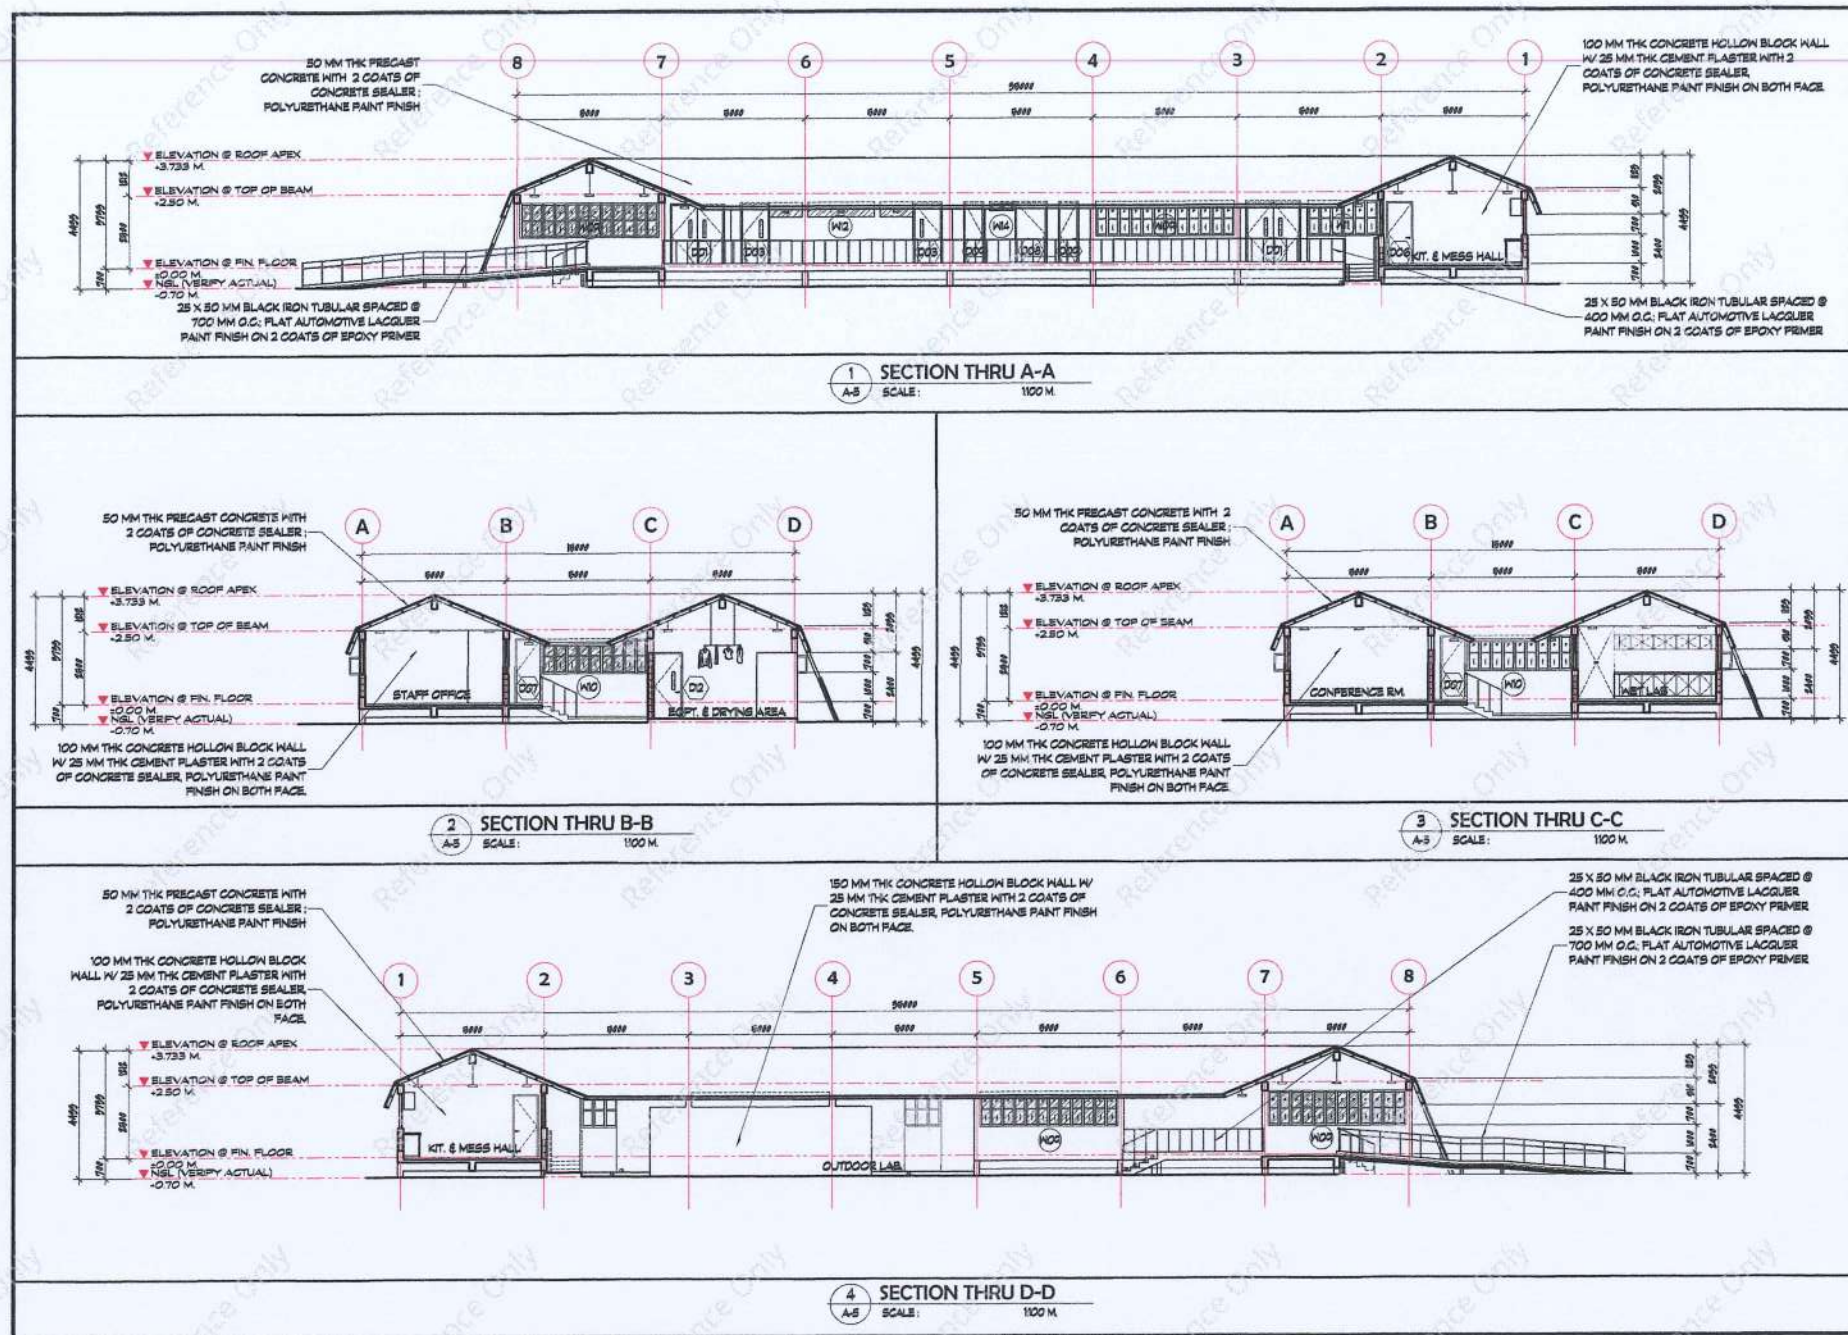
SHEET CONTENTS:
ELEVATIONS

DATE:
MARCH 2025
DRAWN BY: ETL CHECKED BY: PFA3

GRAPHIC SCALE:
1:20 METERS
1:50 METERS
1:100 METERS
1:200 METERS
1:500 METERS
1:1000 METERS

SHEET NO.:

A-4



JORGE YULO ARCHITECTS & ASSOCIATES

3rd Floor Ancestral Center Bldg.
2217 Quezon Avenue, 1st Floor
Makati City, Philippines 1225
Telephone No. (832) 840234
Fax No. (832) 842274

Email Address:
jyulo@jya.com.ph
jyulo@jya.com.ph
URL Address:
http://www.jyulo.com.ph

PTR. NO. 10475571	REG. NO. 12396
ISSUED ON: JAN 08, 2025	TIN NO. 102-325-935
LOCATED AT: MARIKINA CITY	

JORGE MANUEL B. YULO
ARCHITECT

ENGINEER	
PTR. NO.	REG. NO.
ISSUED ON:	TIN NO.
ISSUED AT:	

PROJECT TITLE:
PROPOSED MARINE SCIENTIFIC RESEARCH STATION

LOCATION:
BRGY. PUNTA, APARRI, CAGAYAN, PHILIPPINES

OWNER:
MR. JOSE LITO D. RAZON

SHEET CONTENTS:	
SECTIONS	
DATE: MARCH 2025	
DRAWN BY: STL	CHECKED BY: JYAB
GRAPHIC SCALE:	
SHEET NO. A-5	



**JORGE YULO
ARCHITECTS &
ASSOCIATES**

3rd Floor Automatic Center Bldg.
2207 Quezon Avenue, 2nd
Makati City, Philippines 1211
Telephone No. (812) 882234
Fax No. (812) 882274
Email Address:
jyuloarchitects@gmail.com
jyuloarchitects@yahoo.com
URL Address:
http://www.jyuloarch.com

PRJ. NO.: 10475571 REG. NO.: 12376

ISSUED ON: JAN 08, 2025 TIN NO.: 102-325-935

ISSUED AT: MANGATI CITY

JORGE MANUEL B. YULO
ARCHITECT

ENGINEER

PRJ. NO.: REG. NO.:

ISSUED ON: TIN NO.:

ISSUED AT:

PROJECT TITLE:
**PROPOSED
MARINE SCIENTIFIC
RESEARCH
STATION**

LOCATION:

BIGY, PUNTA
APARRI, CAGAYAN,
PHILIPPINES

OWNER:

MR. JOSEITO D. RAZON

SHEET CONTENTS:


REFLECTED
CEILING
PLAN

DATE:

MARCH 2025


DRAWN BY: ETL CHECKED BY: PFA3

 GRAPHIC SCALE:



SHEET NO.:

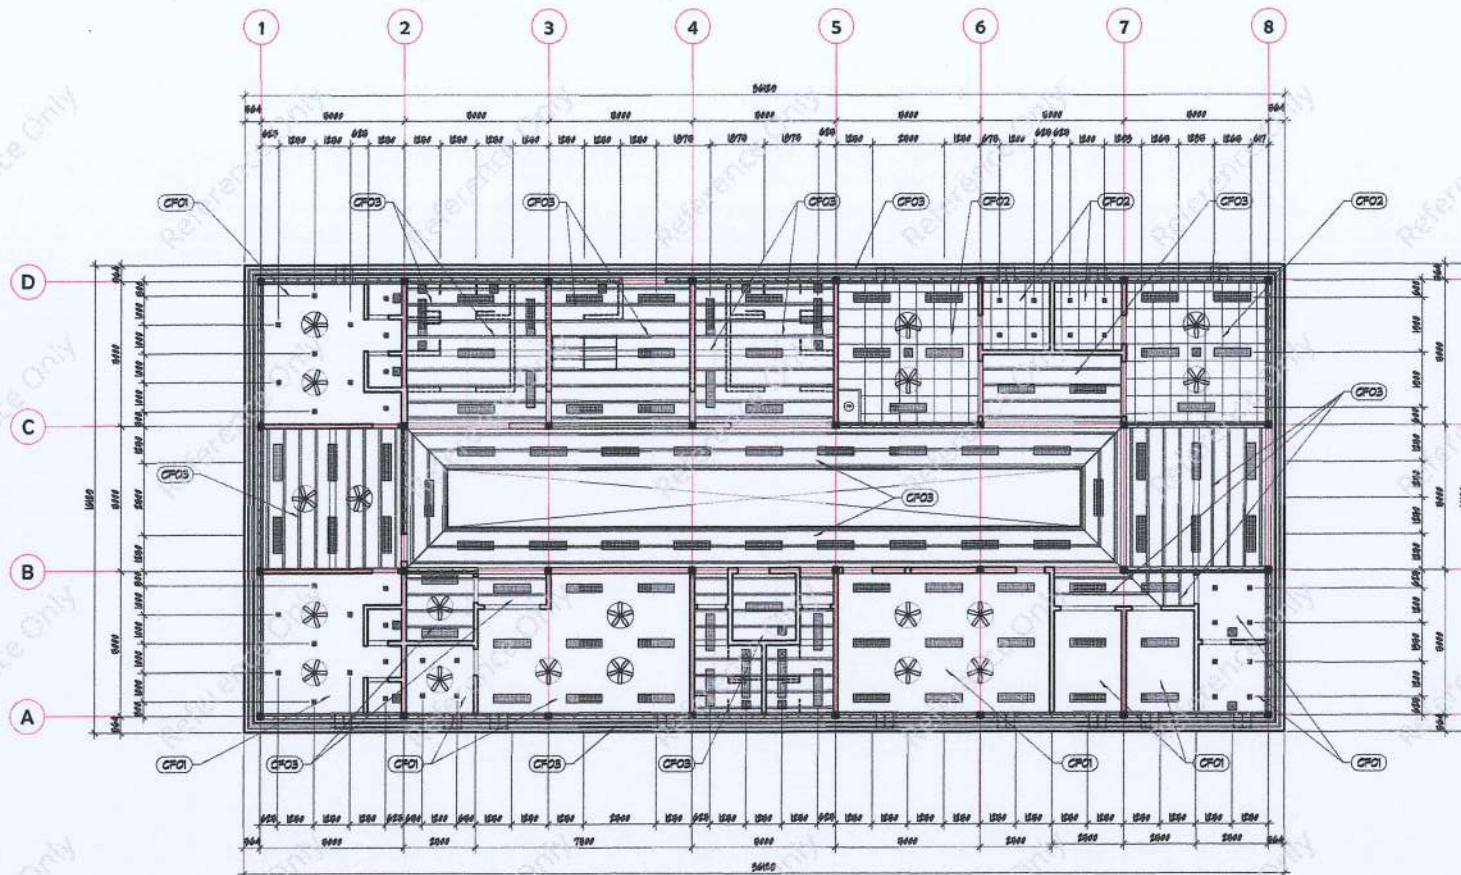A-6



CEILING FINISHES:

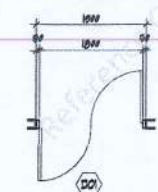
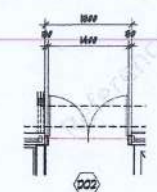
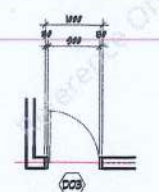
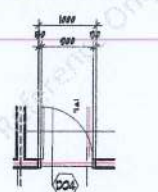
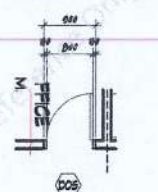
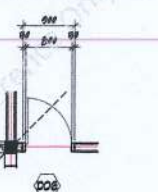
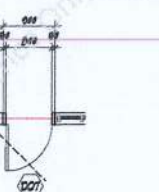
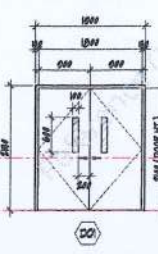
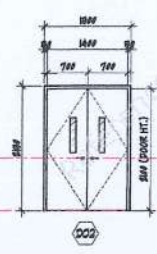
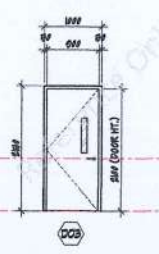
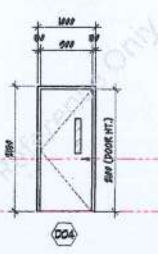
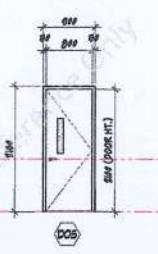
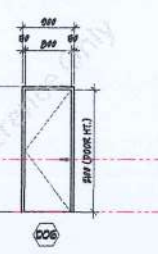
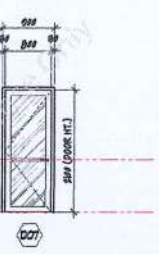
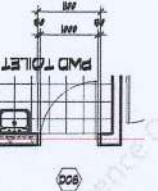
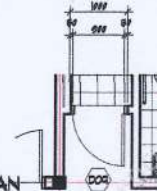
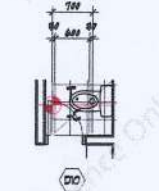
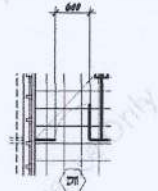
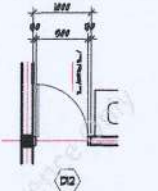
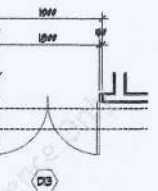
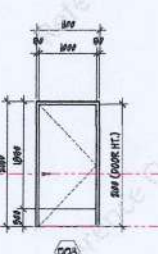
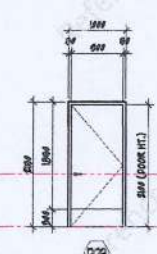
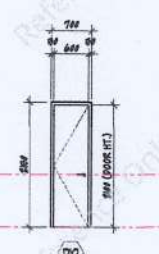
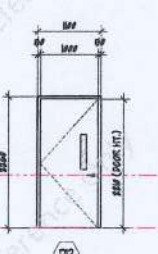
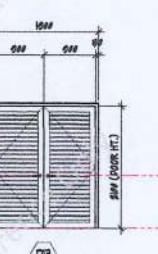
- CPO1** 4.5 MM THK. FIBER CEMENT BOARD CEILING ON METAL FLOORING CHANNELS, PLAT LATEX PAINT FINISH
- CPO2** 600 X 600 MM ACOUSTIC CEILING TILE ON T-RUNNER
- CPO3** EXPOSED UNDER ROOF CEILING

ELECTRICAL LEGEND:

- TROFFER LIGHTING FIXTURE (2-36 WATTS FLUORESCENT)
- EXHAUST FAN
- LABORATORY FUME HOOD
- 10 WATTS LED RECESSED PIN LIGHT
- OSCILLATING CEILING FAN

1 REFLECTED CEILING PLAN
A-6 SCALE: 1/100 M.

MSRS_Cagayan_p.8

 PLAN D01	 PLAN D02	 PLAN D03	 PLAN D04	 PLAN D05	 PLAN D06	 PLAN D07
 ELEV. D01	 ELEV. D02	 ELEV. D03	 ELEV. D04	 ELEV. D05	 ELEV. D06	 ELEV. D07
D01 FOUR (4) SETS STAFF OFFICE, CLING, LABORATORIES SOLID CORE DOUBLE SWING DOOR WITH 6MM THK NARROW LITE ON BOTH LEAF ON A FR. 50 X 100 DOOR JAMB FRAME, FLAT BLACK PAINT FINISH	D02 ONE (1) SET EQUIPMENT & DRYING AREA SOLID CORE DOUBLE SWING DOOR WITH 6MM THK NARROW LITE ON BOTH LEAF ON A FR. 50 X 100 DOOR JAMB FRAME, FLAT BLACK PAINT FINISH	D03 FIVE (5) SETS LECTURE RM, LIBRARY, SERVER AND BLEG. RM. SOLID CORE SINGLE SWING DOOR WITH 6MM THK NARROW LITE ON A FR. 50 X 100 DOOR JAMB FRAME, FLAT BLACK PAINT FINISH	D04 TWO (2) SETS LABORATORY STORAGE ROOMS SINGLE SWING METAL DOOR WITH 6MM THK NARROW LITE ON A FR. 50 X 100 DOOR JAMB FRAME, FLAT BLACK PAINT FINISH	D05 TWO (2) SETS DR. OFFICE & CCTV ROOM SOLID CORE SINGLE SWING DOOR WITH 6MM THK NARROW LITE ON A FR. 50 X 100 DOOR JAMB FRAME, FLAT BLACK PAINT FINISH	D06 FOUR (4) SETS QUARTERS & GUARD HOUSE SOLID CORE SINGLE SWING DOOR ON A FR. 50 X 100 DOOR JAMB FRAME, FLAT BLACK PAINT FINISH	D07 ONE (1) SET KITCHEN & MESS HALL 6MM THK SINGLE SWING ALUMINUM FRAMED GLASS DOOR, BLACK ANODIZ FINISH
 PLAN D08	 PLAN D09	 PLAN D10	 PLAN D11	 PLAN D12	 PLAN D13	
 ELEV. D08	 ELEV. D09	 ELEV. D10	 ELEV. D11	 ELEV. D12	 ELEV. D13	
D08 ONE (1) SET PMD TOILET SOLID CORE SINGLE SWING DOOR WITH 15 MM THK SS KICK PLATE ON 50 X 100 DOOR JAMB FRAME, FLAT BLACK PAINT FINISH	D09 TWO (2) SETS MALE AND FEMALE TOILET SOLID CORE SINGLE SWING DOOR WITH 15 MM THK SS KICK PLATE ON 50 X 100 DOOR JAMB FRAME, FLAT BLACK PAINT FINISH	D10 FIVE (5) SETS TBS AT QUARTERS AND GUARDHOUSE HOLLOW CORE SINGLE SWING DOOR ON A FR. 50 X 100 DOOR JAMB FRAME, FLAT BLACK PAINT FINISH	D11 TEN (10) SETS SHOWER & TOILET & BOPT/DRYING AREA 12MM THK HIGH PRESSURE LAMINATE (VERIFY TYPE)	D12 TWO (2) SETS EQUIPMENT & DRYING AREA SOLID WOOD SINGLE SWING DOOR WITH 6MM THK NARROW LITE ON A FR. 50 X 100 DOOR JAMB FRAME, FLAT BLACK PAINT FINISH	D13 TWO (2) SETS GENSET & PUMP ROOM 50 X 100 X 15 MM THK LOUVERED STEEL DOUBLE SWING DOOR ON 50 X 100 STEEL JAMB, FLAT BLACK PAINT FINISH	

1 DOORS & WINDOWS SCHEDULE
A-7 SCALE: 1:50 M.

MSRS_Cagayan_p.9

JORGE YULO ARCHITECTS & ASSOCIATES

3rd Floor Automatic Center Bldg.
2227 Quezon Avenue, 1201
Manila City, Philippines 1201
Telephone No. (02) 8452344
Fax No. (02) 8452374
Email Address: jayulo@jorgeyulo.com
jyulo@jorgeyulo.com
URL Address: http://www.jorgeyulo.com

PTR NO.: 10475571 REG. NO.: 12396
ISSUED ON: JAN 08, 2025 TIN NO.: 102-325-935

ISSUED AT: MANKATI CITY

JORGE MANUEL B. YULO
ARCHITECT

ENGINEER

PTR NO.: REG. NO.:
ISSUED ON: TIN NO.:
ISSUED AT:

PROJECT TITLE:
PROPOSED MARINE SCIENTIFIC RESEARCH STATION

LOCATION:
BREG, PUNTA APARRI, CAGAYAN, PHILIPPINES

OWNER:
MR. JOSELO D. RAZON

SHEET CONTENTS:
DOORS AND WINDOWS SCHEDULE

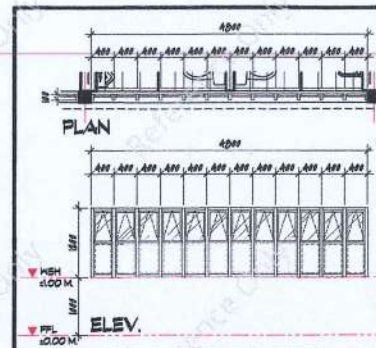
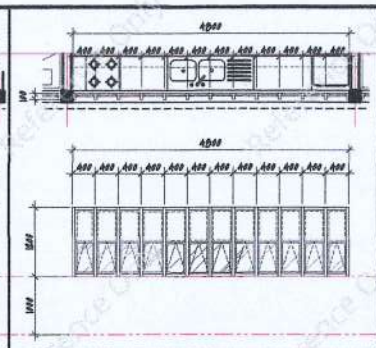
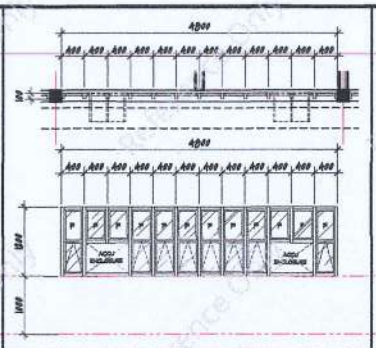
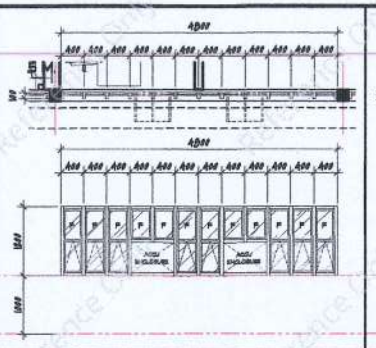
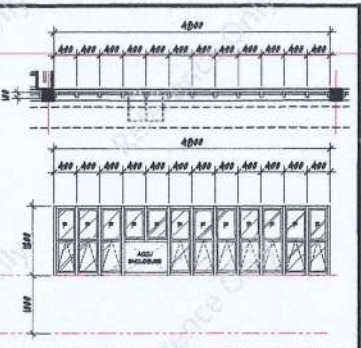
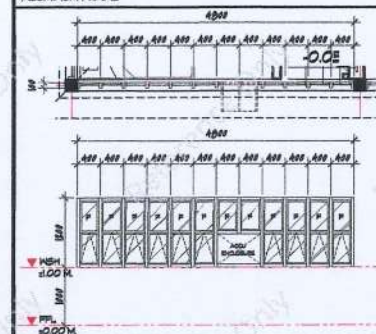
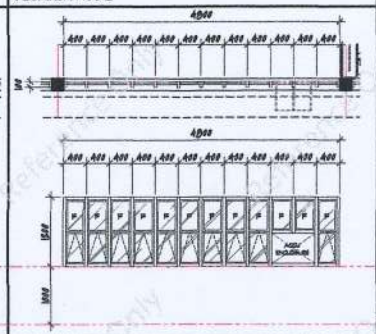
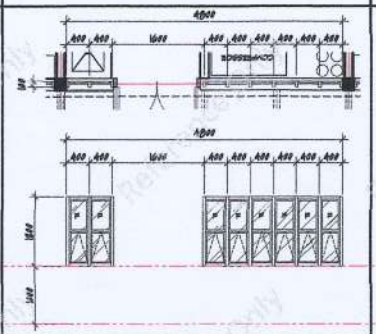
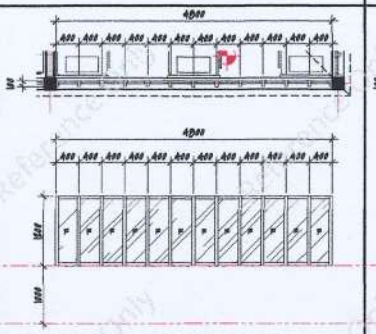
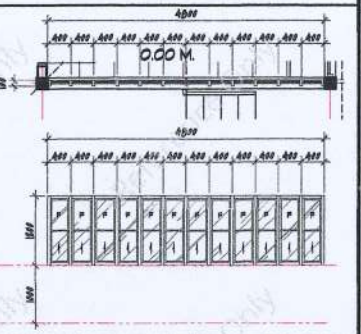
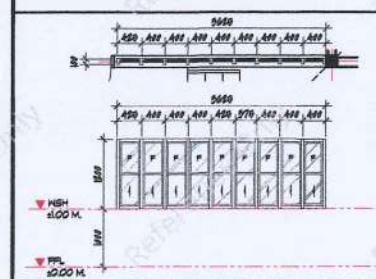
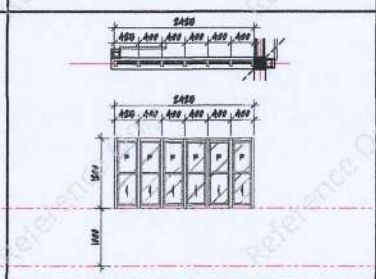
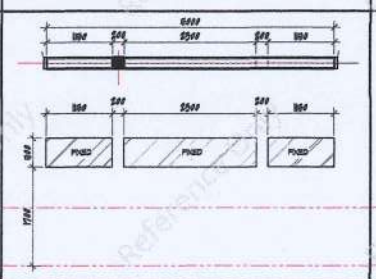
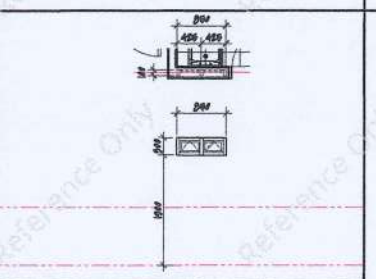
DATE: MARCH 2025
DRAWN BY: ETL CHECKED BY: RPP/AS

GRAPHIC SCALE:
1:50 METERS
0 5 10 15 20
1:100 METERS
0 5 10 15 20
1:200 METERS
0 5 10 15 20

SHEET NO.:

A-7

- NOTE:
1. VERIFY ACTUAL DIMENSIONS ON SITE PRIOR TO FABRICATION OF DOORS AND WINDOWS.
 2. VERIFY GLASS THICKNESS W/ THE SUPPLIER AND/OR MANUFACTURER CONTRACTOR TO SUBMIT MOCK UP PRIOR TO FABRICATION OF DOORS AND WINDOWS
 - 3.

 PLAN ELEV.				
W01 THREE (3) SETS (M/F) PUBLIC TOILETS AND LAUNDRY AREAS 6MM THK CLEAR GLASS ANNING WINDOW (TOP) AND BLACK FIXED ALUMINUM COMPOSITE PANELS (BOT) IN BLACK ANALOK ALUMINUM FRAME	W02 THREE (3) SETS MESS HALL, DRY LAB, ELEC. AND SERVER RM. 6MM THK CLEAR GLASS ANNING WINDOW (TOP) AND BLACK FIXED ALUMINUM COMPOSITE PANELS (BOT) IN BLACK ANALOK ALUMINUM FRAME	W03 THREE (3) SETS CLINIC & LECTURE HALL, LAB, STORAGE, LIBRARY, SERVER RM. 6MM THK CLEAR GLASS FIXED AND ANNING WINDOW IN BLACK ANALOK ALUMINUM FRAME WITH ACCU ENCLOSURE	W04 ONE (1) SET DIRECTORS AND STAFF OFFICE 6MM THK CLEAR GLASS FIXED AND ANNING WINDOW IN BLACK ANALOK ALUMINUM FRAME WITH ACCU ENCLOSURE	W05 THREE (3) SETS LECTURE HALL & LABORATORIES 6MM THK CLEAR GLASS FIXED AND ANNING WINDOW IN BLACK ANALOK ALUMINUM FRAME WITH ACCU ENCLOSURE
				
W06 TWO (2) SETS RESEARCHERS ROOM 6MM THK CLEAR GLASS FIXED AND ANNING WINDOW IN BLACK ANALOK ALUMINUM FRAME WITH ACCU ENCLOSURE	W07 ONE (1) SET STAFF OFFICE 6MM THK CLEAR GLASS FIXED AND ANNING WINDOW IN BLACK ANALOK ALUMINUM FRAME WITH ACCU ENCLOSURE	W08 ONE (1) SET EQUIPMENT & CRYING AREA 6MM THK CLEAR GLASS FIXED AND ANNING WINDOW IN BLACK ANALOK ALUMINUM FRAME	W09 TWO (2) SETS RESEARCHERS ROOM 6MM THK PROTECTED GLASS FIXED WINDOW IN BLACK ANALOK ALUMINUM FRAME	W10 FOUR (4) SETS STAFF OFFICE, LABORATORIES, LIBRARY HALLWAY 6MM THK CLEAR GLASS SINGLE HUNG WINDOW IN BLACK ANALOK ALUMINUM FRAME
				NOTE 1. VERIFY ACTUAL DIMENSIONS ON SITE PRIOR TO FABRICATION OF DOORS AND WINDOWS. 2. VERIFY GLASS THICKNESS W/ THE SUPPLIER AND/OR MANUFACTURER CONTRACTOR TO SUBMIT MOCK UP PRIOR TO FABRICATION OF DOORS AND WINDOWS. 3.
W11 ONE (1) SET MESS HALL 6MM THK CLEAR GLASS SINGLE HUNG WINDOW IN BLACK ANALOK ALUMINUM FRAME	W12 ONE (1) SET CCTV ROOM 6MM THK CLEAR GLASS SINGLE HUNG WINDOW IN BLACK ANALOK ALUMINUM FRAME	W13 ONE (1) SET CONFERENCE/LECTURE HALL 12 MM THK CLEAR FRAMELESS TEMPERED GLASS	W14 ONE (1) SET PND TOILET 6MM THK CLEAR GLASS ANNING WINDOW IN BLACK ANALOK ALUMINUM FRAME	

1 DOORS & WINDOWS SCHEDULE
A-7A SCALE: 1:50 M



JORGE YULO ARCHITECTS & ASSOCIATES

3rd Floor Automatic Center Bldg.
2157 Quezon Avenue, Quezon City, Philippines 1101
Telephone No. (02) 8622134
Fax No. (02) 8622174

Email Address:
jyulo@jorgeyulo.com
jyulo_a@jorgeyulo.com
URL: <http://www.jorgeyulo.com>

PTR. NO.: 10475571 REG. NO.: 12396

ISSUED ON: JAN 08, 2025 TPN NO.: 102-325-935

ISSUED AT: MARIKINA CITY

JORGE MANUEL B. YULO
ARCHITECT

ENGINEER

PTR. NO.: REG. NO.

ISSUED ON: TPN NO.

ISSUED AT:

PROJECT TITLE:
PROPOSED MARINE SCIENTIFIC RESEARCH STATION

LOCATION:
BRGY. PUNTA APARRI, CAGAYAN, PHILIPPINES

OWNER:
MR. JOSELO D. RAZON

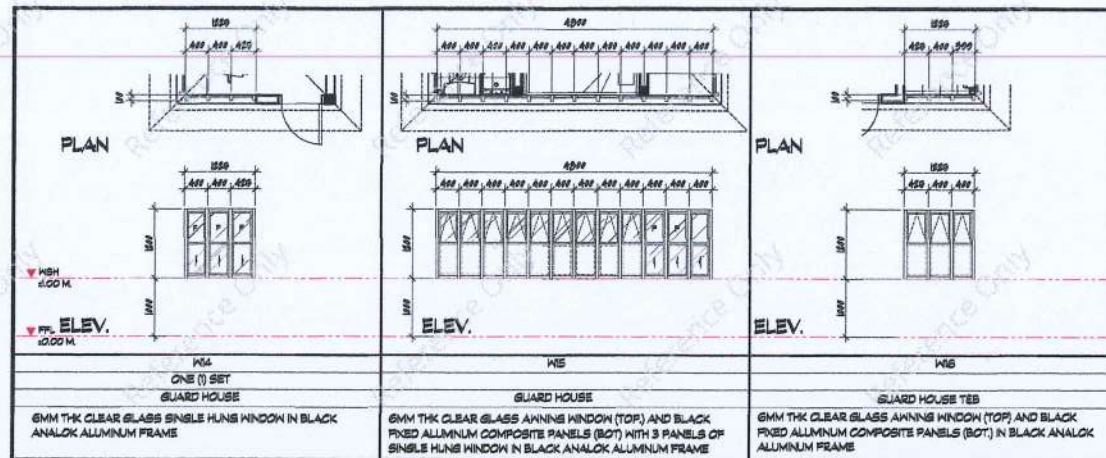
SHEET CONTENTS:
DOORS AND WINDOWS SCHEDULE

DATE:
MARCH 2025



DRAWN BY: EYL CHECKED BY: PFAS

GRAPHIC SCALE:
1:50 METERS
0 10 20 30 40 50 60 70 80 90 100
1:10 METERS
0 10 20 30 40 50 60 70 80 90 100
1:20 METERS
0 10 20 30 40 50 60 70 80 90 100

SHEET NO.:
A-7A



1 WINDOWS SCHEDULE
SCALE: 1:50 M.

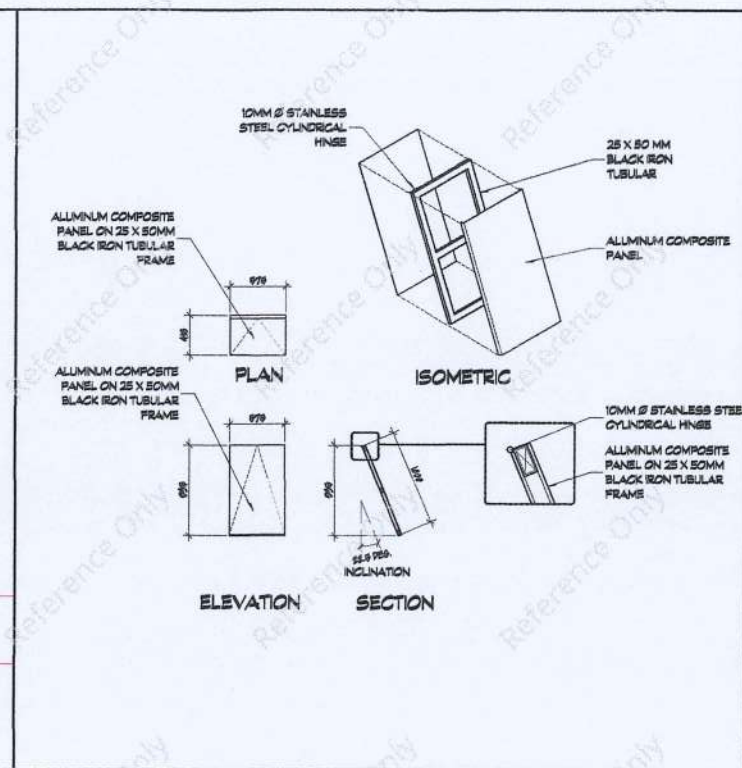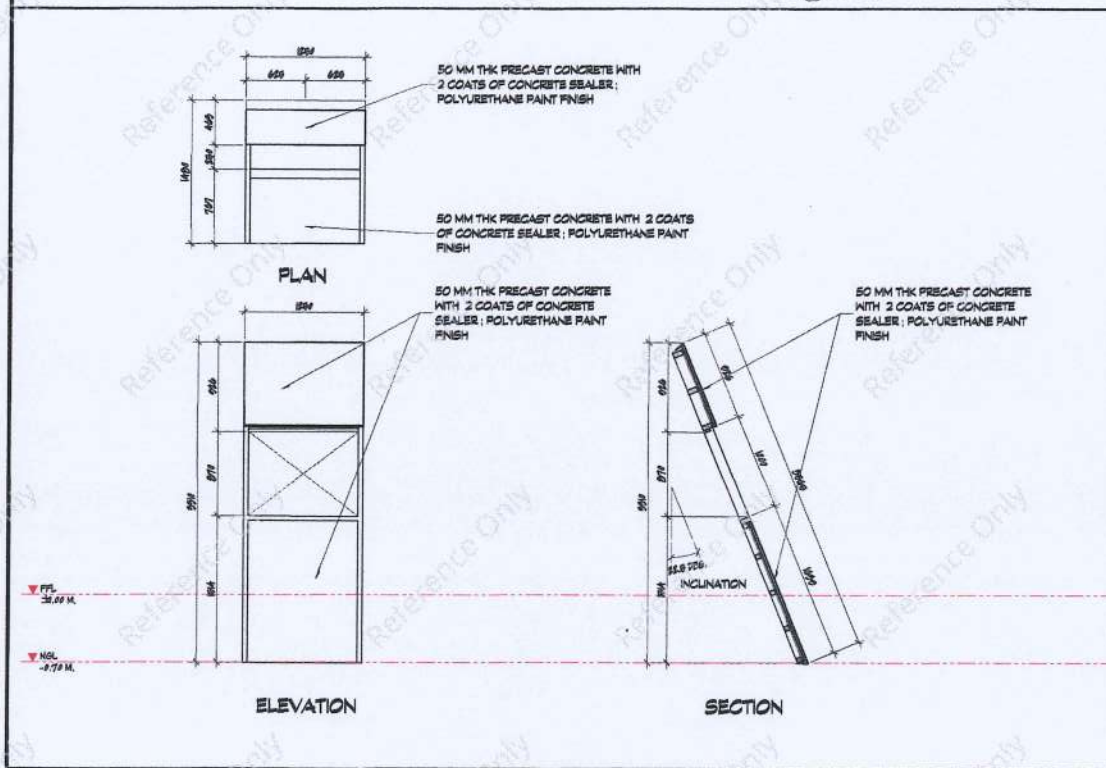

JORGE YULO ARCHITECTS & ASSOCIATES

3rd Floor Automatic Center Bldg.
2227 Old China House Ave. Bldg.
Makati City, Philippines 1211
Telephone No. (02) 845254
Fax No. (02) 845274
E-mail Address: jorgeyulo@jorgeyulo.com
jorge.yulo@jorgeyulo.com
URL Address: http://www.jorgeyulo.com

PTR NO. 10475571 REG. NO. 12396
ISSUED ON: JAN 08, 2025 TIN NO. 102-325-435
ISSUED AT: MAKATI CITY

JORGE MANUEL B. YULO
ARCHITECT

ENGINEER
PTR NO. REG. NO.
ISSUED ON: TIN NO.
ISSUED AT:

PROJECT TITLE:
PROPOSED MARINE SCIENTIFIC RESEARCH STATION
LOCATION:
BREGY, PUNTA, AFIARRI, CAGAYAN, PHILIPPINES

OWNER:
MR. JOSELOITO D. RAZON

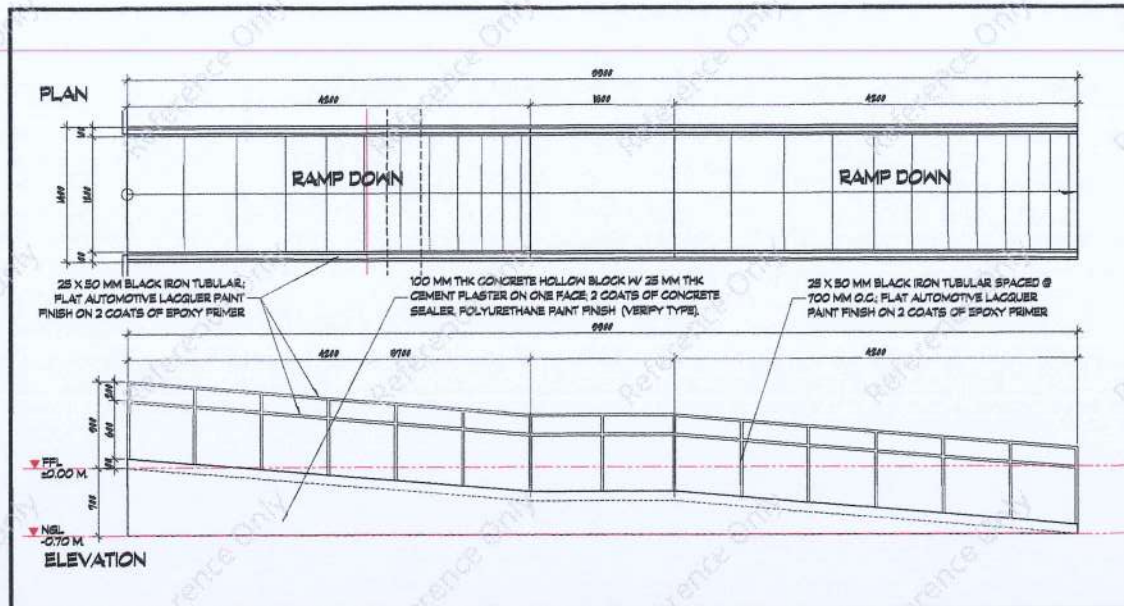
SHEET CONTENTS:
WINDOWS SCHEDULE, WINDOW SHUTTER & DEFLECTOR DETAILS

DATE: MARCH 2025
DRAWN BY: STL CHECKED BY: PRAAS


GRAPHIC SCALE:
1:30 METERS 1:50 METERS 1:75 METERS
1:100 METERS 1:200 METERS 1:300 METERS

SHEET NO.:

A-7B



1 CONCRETE RAMP DETAILS
SCALE: 1/30 M.

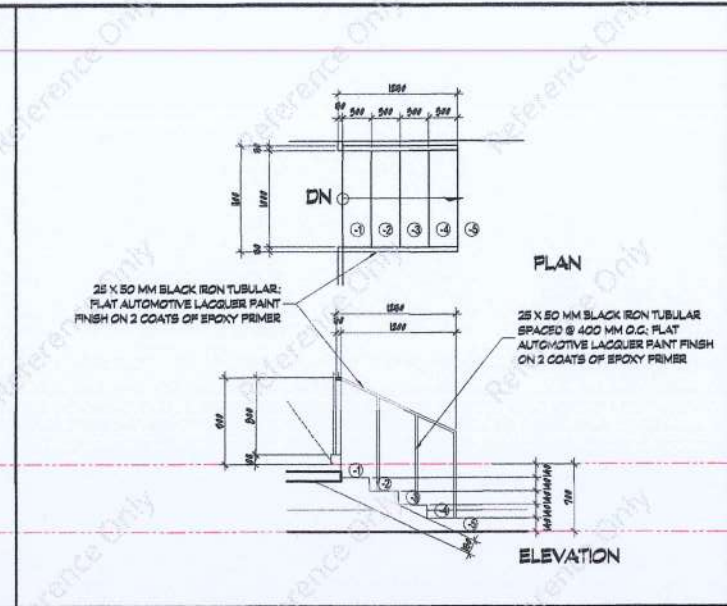

2 STAIR DETAILS
SCALE: 1/30 M.



**JORGE YULO
ARCHITECTS & ASSOCIATES**

3rd Floor Alameda Center Bldg.
2201 Don Chino Rivera Ave. 80th
Floor City, Philippines 1241
Telephone Nos. (02) 8450548
8450574
8450576
Fax No. (02) 8450576
Email Address
jyuloarchitects@gmail.com
jyulo_architects@yahoo.com
URL: www.jorgeyulo.com

PTR NO. 10475571 REG. NO. 12396

ISSUED ON: JAN 08, 2025 TIN NO. 102-325-935

ISSUED AT: MANKATI CITY

JORGE MANUEL B. YULO
ARCHITECT

ENGINEER

PTR NO. 10475571 REG. NO. 12396

ISSUED ON: JAN 08, 2025 TIN NO. 102-325-935

ISSUED AT: MANKATI CITY

PROJECT TITLE:
**PROPOSED
MARINE SCIENTIFIC
RESEARCH
STATION**

LOCATION:
**BREY, PUNTA
APARRI, CAGAYAN,
PHILIPPINES**

OWNER:

MR. JOSELITO D. RAZON

SHEET CONTENTS:

RAMP AND STAIR DETAILS

DATE:
MARCH 2025

DRAWN BY:
ETL

CHECKED BY:
PPA3

GRAPHIC SCALE:

1:30 METERS

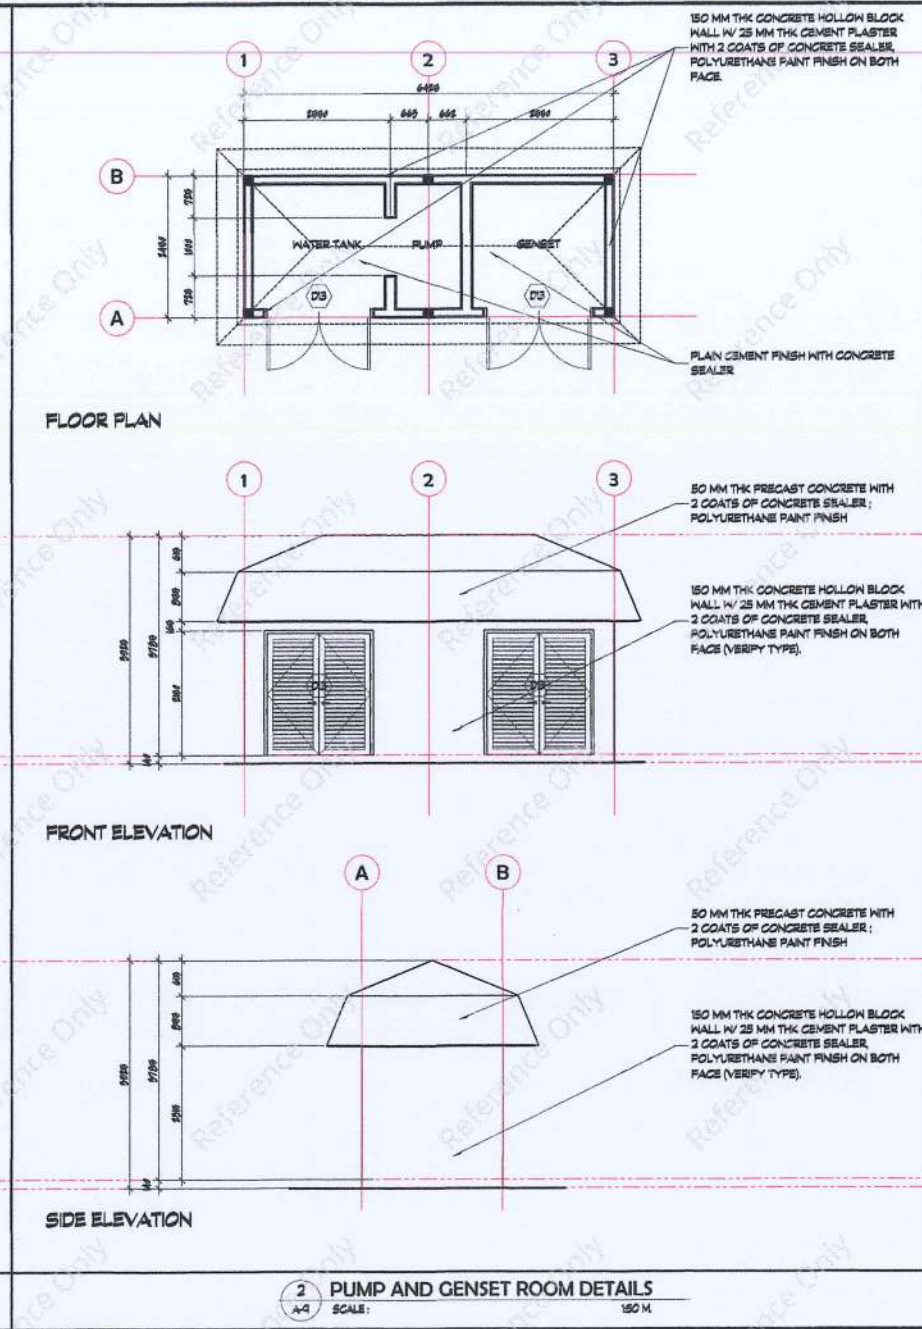
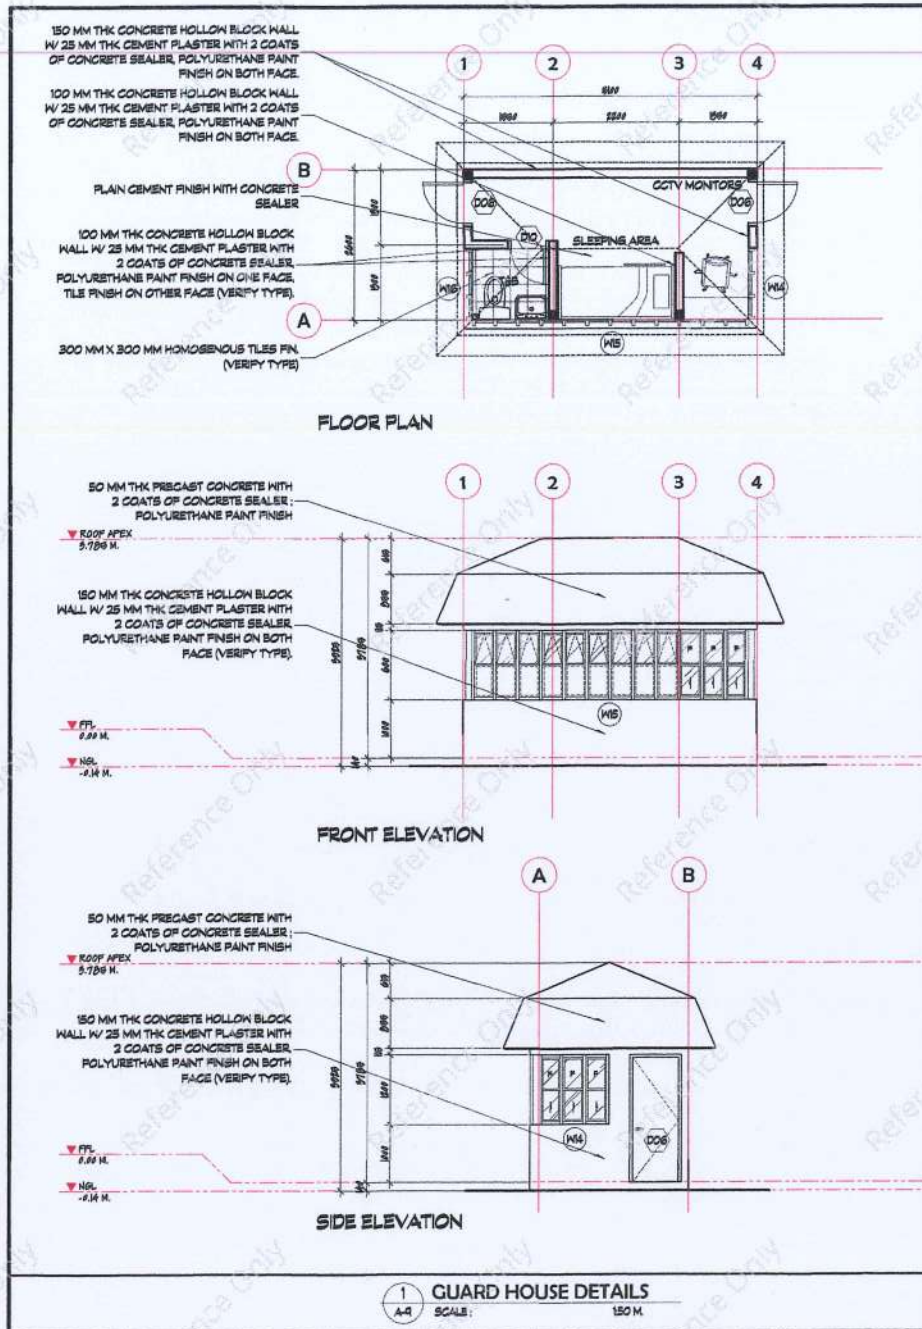
1:10 METERS

1:100 METERS

1:1000 METERS

SHEET NO.:

A-8



JORGE YULO ARCHITECTS & ASSOCIATES

3rd Floor Automatic Center Bldg.
2527 Don Chino Reyes Ave. Edif.
Makati City, Philippines 1211
Telephone No. (832) 882334
Fax No. (832) 882374

2526B Address:
jorgeyulo@jorgeyulo.com
jyulo_jm@jorgeyulo.com
URL Address:
jorgeyulo.com

PTR NO.: 10475571	REG. NO.: 12376
ISSUED ON: JAN 08, 2025	TIN NO.: 102-325-935
ISSUED AT: MAKATI CITY	

JORGE MANUEL B. YULO
ARCHITECT

ENGINEER

PTR NO.:	REG. NO.:
ISSUED ON:	TIN NO.:
ISSUED AT:	

PROJECT TITLE:
PROPOSED MARINE SCIENTIFIC RESEARCH STATION

LOCATION:
BRGY. PUNTA APARRI, CAGAYAN, PHILIPPINES

OWNER:
MR. JOSELOTO D. RAZON

SHEET CONTENTS:
GUARD HOUSE, PUMP ROOM AND GENSET ROOM DETAILS

DATE:
MARCH 2025

DRAWN BY:
ETL

CHECKED BY:
PPAS

GRAPHIC SCALE:
1:50 METERS
0 10 20 30
1:100 METERS
0 10 20 30
1:200 METERS
0 10 20 30

SHEET NO.:
A-9



Department of Environment and Natural Resources

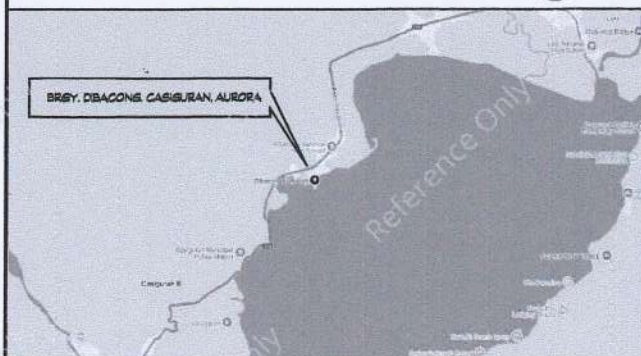
ARCHITECTURAL DESIGN

CASIGURAN, AURORA


MARINE SCIENTIFIC RESEARCH STATION



1 PERSPECTIVES
CS-1 SCALE: N.T.S.



2 VICINITY MAP
CS-1 SCALE: N.T.S.

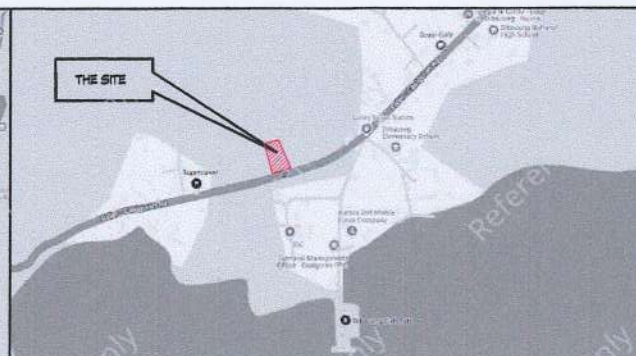

3 LOCATION MAP
CS-1 SCALE: N.T.S.

TABLE OF CONTENTS		REPUBLIC OF THE PHILIPPINES DEPARTMENT OF PUBLIC WORKS AND HIGHWAYS OFFICE OF THE BUILDING OFFICIAL		
ARCHITECTURAL	ELECTRICAL	LAND USE/ZONING	JORGE YULO ARCHITECTS & ASSOCIATES 37 Automart Center, 2218 Don Orino Bypass Avenue, Esteroles, Makati City, Philippines 1202 Telephone No. (02) 8453074 8453074 Fax No. (02) 8453074 Email Address: jyulo@jorgeyulo.com URL: http://www.jorgeyulo.com	
CS-1 PERSPECTIVES VICINITY MAP A-1 SITE LOCATION MAP A-2 FLOOR PLAN A-3 ROOF PLAN A-4 ELEVATIONS A-5 SECTIONS A-6 REFLECTED CEILING PLAN A-7 DOORS AND WINDOWS SCHEDULE A-7a DOORS AND WINDOWS SCHEDULE A-8 WIND DEFLECTOR, WINDOW SHUTTER, RAMP, AND STAIR DETAILS A-4 GUARD HOUSE, PUMP ROOM, AND SENSIT DETAILS	MECHANICAL			LINE AND GRADE
STRUCTURAL				
SANITARY		STRUCTURAL		
	SANITARY			
	ELECTRICAL			
		MECHANICAL	PROJECT TITLE: PROPOSED MARINE SCIENTIFIC RESEARCH STATION LOCATION : BRGY. DIBACONG, CASIGURAN, AURORA, PHILIPPINES OWNER: MR. ALFREDO B. COLLADO SHEET CONTENTS: PERSPECTIVES VICINITY MAP LOCATION MAP DATE: MARCH 2025 DRAWN BY: ETL CHECKED BY: PPAB GRAPHIC SCALE: 1:100 METERS 0 50 100 150 200 1:100 METERS 0 50 100 150 200 1:100 METERS 0 50 100 150 200 SHEET NO.: CS-1	

JORGE YULO ARCHITECTS & ASSOCIATES
3F Antares Center, 2558 Don
Ordo Street, Marikina City, Philippines 1802
Tel: 0917 845074
Fax: 0917 845074
Email: jorge_yulo@jorgeyulo.com
URL: www.jorgeyulo.com

PTB NO.: 10475571
REG. NO.: 12396
ISSUED ON: JAN. 08, 2025
TIN NO.: 102-325-935

ISSUED AT: MAKATI CITY

JORGE MANUEL B. YULO
ARCHITECT

ENGINEER

PTB NO.:
REG. NO.:

ISSUED ON: TIN NO:

ISSUED AT:

PROJECT TITLE:
PROPOSED
MARINE SCIENTIFIC
RESEARCH
STATION

LOCATION:
BRGY. DIBACONG,
CASIGURAN, AURORA,
PHILIPPINES

OWNER:
MR. ALFREDO B. COLLADO

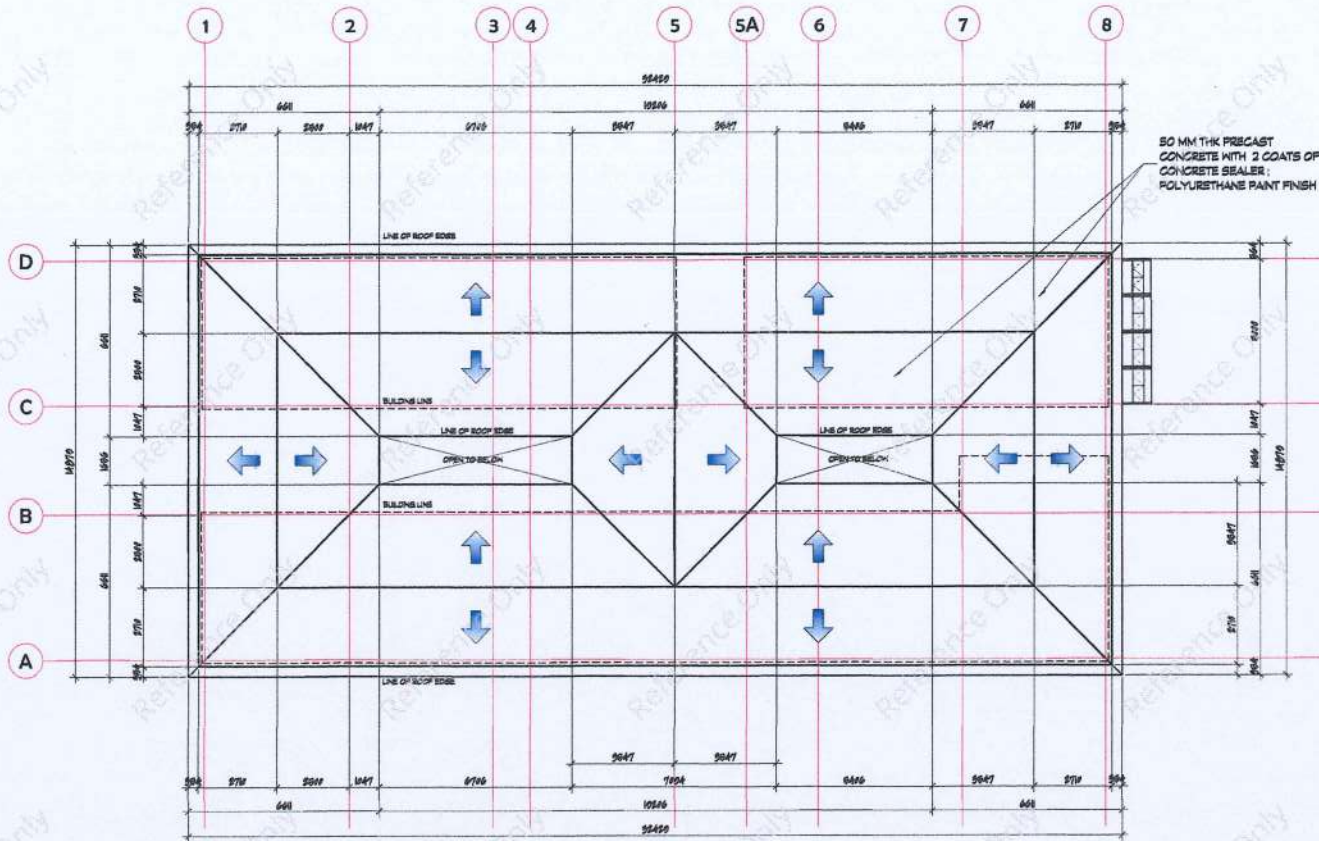
SHEET CONTENTS:
PERSPECTIVES
VICINITY MAP
LOCATION MAP

DATE:
MARCH 2025
DRAWN BY:
ETL CHECKED BY:
PPAS

GRAPHIC SCALE:
1:100 METERS
1:500 METERS
1:1000 METERS
1:2000 METERS

SHEET NO.:

CS-1



1 AURORA MSRS ROOF PLAN
A-3 SCALE: 1/200 N.

MSRS_Aurora_p.4

JORGE YULO ARCHITECTS & ASSOCIATES

3rd Floor Automatic Center Bldg.
2107 Quezon Avenue, 2nd Fl.
Kamak, Quezon City, Philippines 1211
Telephone No. (02) 8852334
Fax No. (02) 8852374
E-mail Address: jorgeyulo@jorgeyulo.com
jorge_yulo@yahoo.com
URL Address: http://www.jorgeyulo.com

PTN NO.: 10475571
REG. NO.: 12396
ISSUED ON: JAN 08, 2025
TIN NO.: 102-325-935

ISSUED AT: MAKATI CITY

JORGE MANUEL B. YULO
ARCHITECT

ENGINEER

PTN NO.: 10475571
REG. NO.: 12396

ISSUED ON: JAN 08, 2025
TIN NO.: 102-325-935

ISSUED AT: MAKATI CITY

PROJECT TITLE:
PROPOSED
MARINE SCIENTIFIC
RESEARCH
STATION

LOCATION:
BRGY. DIBACONG,
CAGSIGURAN, AURORA,
PHILIPPINES

OWNER:

MR. ALFREDO B. COLLADO

SHEET CONTENTS:
ROOF PLAN

DATE:
MARCH 2025

DRAWN BY: ETL
CHECKED BY: RPAAS

GRAPHIC SCALE:
1:20 METERS
1:50 METERS
1:100 METERS
1:200 METERS

SHEET NO.:

A-3



**JORGE YULO
ARCHITECTS & ASSOCIATES**

3rd Floor, Asean Building, 8th St.,
22nd St. Corner, 8th St. & 22nd St.,
Manila City, Philippines 1011
Telephone No. (02) 8452734
Fax No. (02) 8452734

Email Address:
jorge@jorgeyulo.com
info@jorgeyulo.com
URL Address:
http://www.jorgeyulo.com

PTF NO.: 10475571 REG. NO. 12396

ISSUED ON: JAN 08, 2025 TIN NO. 102-325-935

ISSUED AT: MANKATI CITY

JORGE MANUEL B. YULO
ARCHITECT

ENGINEER

PTF NO. REG. NO.

ISSUED ON: TIN NO.

ISSUED AT:

PROJECT TITLE:
**PROPOSED
MARINE SCIENTIFIC
RESEARCH
STATION**

LOCATION:
BRGY. DIBACONG,
CAGSIGURAN, AURORA,
PHILIPPINES

OWNER:

MR. ALFREDO B. COLLADO

SHEET CONTENTS:
ELEVATIONS

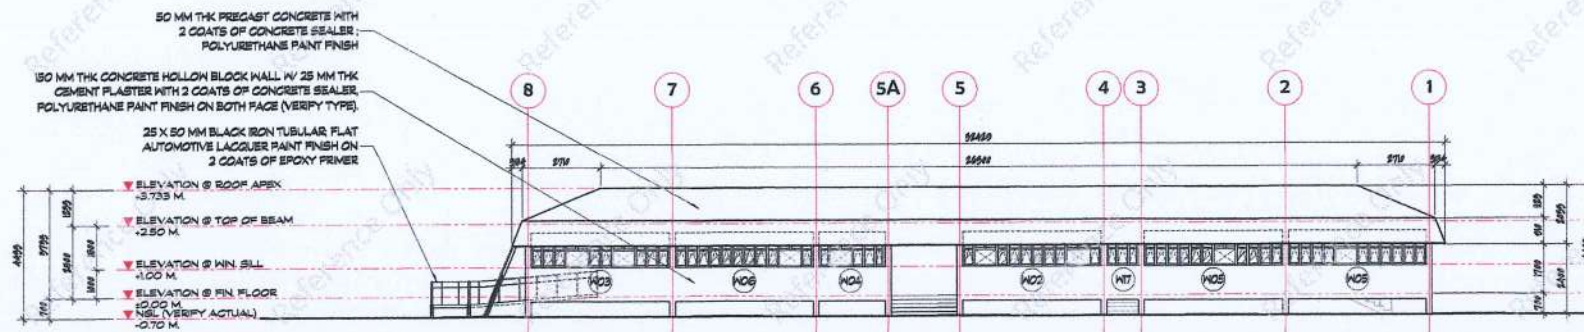
DATE:
MARCH 2025

DRAWN BY: ETL CHECKED BY: MPAS


GRAPHIC SCALE:
1:25 METERS
1:50 METERS
1:100 METERS
1:200 METERS
1:400 METERS
1:800 METERS
1:1600 METERS

SHEET NO.:


A-4




1 FRONT ELEVATION
SCALE: 1:100 M.

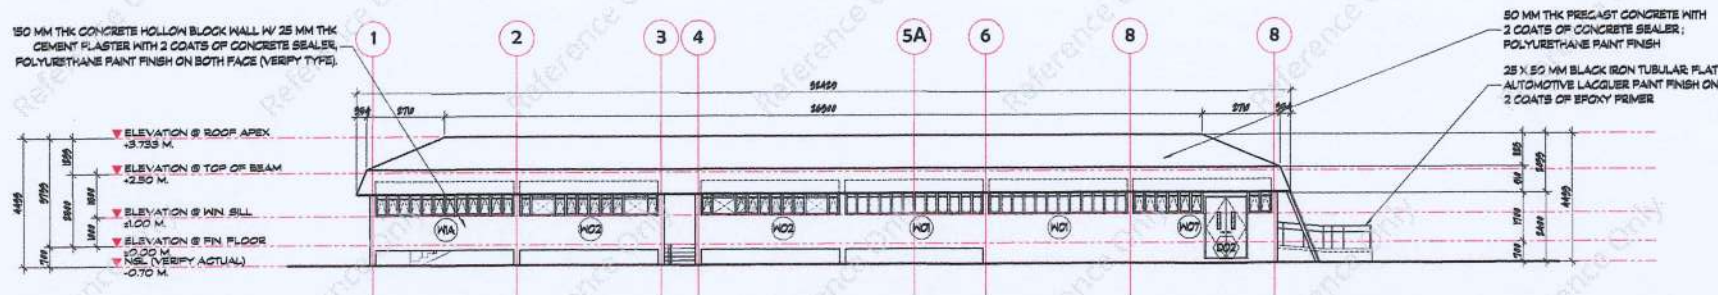

2 REAR ELEVATION
SCALE: 1:100 M.

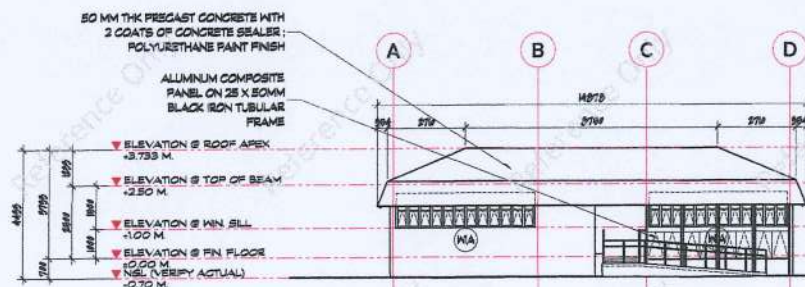


3 LEFT SIDE ELEVATION
SCALE: 1:100 M.

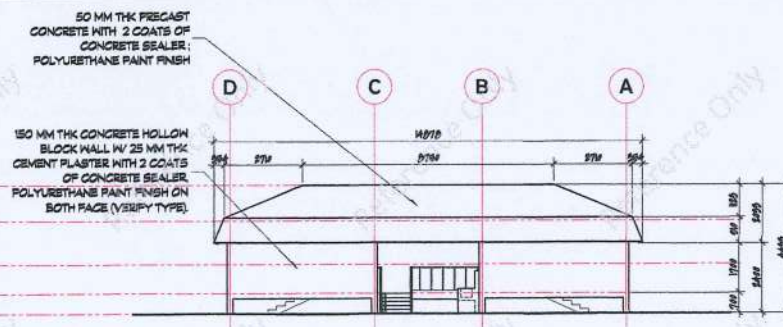

4 RIGHT SIDE ELEVATION
SCALE: 1:100 M.

100 MM THK CONCRETE HOLLOW BLOCK WALL W/
25 MM THK CEMENT PLASTER WITH 2 COATS OF
CONCRETE SEALER, POLYURETHANE PAINT FINISH
ON BOTH FACE.

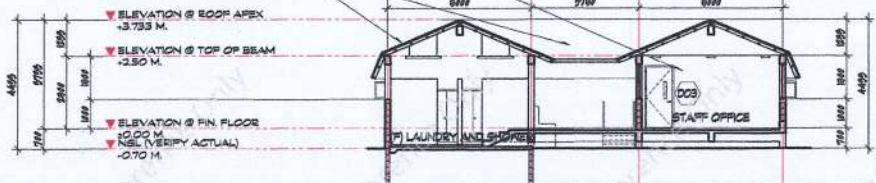
50 MM THK PRECAST CONCRETE WITH
2 COATS OF CONCRETE SEALER,
POLYURETHANE PAINT FINISH



1 SECTION THRU A-A
SCALE: 1/200 M.


275 MM THK (2-100 MM) CONCRETE HOLLOW BLOCK
WALL, 25 MM THK CEMENT PLASTER WITH 2 COATS OF
CONCRETE SEALER, POLYURETHANE PAINT FINISH ON
ONE FACE, TLB FINISH ON OTHER FACE (VERIFY TYPE)

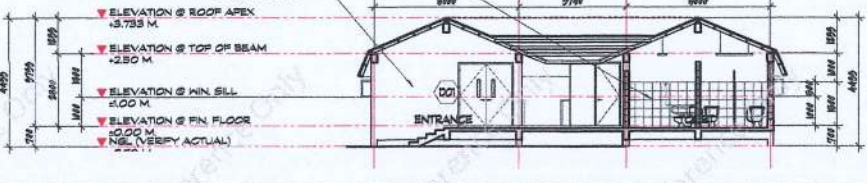100 MM THK CONCRETE HOLLOW BLOCK WALL W/
25 MM THK CEMENT PLASTER WITH 2 COATS OF
CONCRETE SEALER, POLYURETHANE PAINT FINISH
ON BOTH FACE.



2 SECTION THRU B-B
SCALE: 1/200 M.

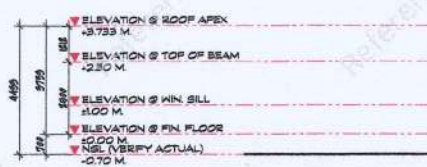25 X 50 MM BLACK IRON TUBULAR FLAT
AUTOMOTIVE LAGUER PAINT FINISH ON
2 COATS OF EPOXY PRIMER




3 SECTION THRU C-C
SCALE: 1/200 M.

50 MM THK PRECAST CONCRETE WITH
2 COATS OF CONCRETE SEALER,
POLYURETHANE PAINT FINISH

150 MM THK CONCRETE HOLLOW BLOCK WALL W/
25 MM THK CEMENT PLASTER WITH 2 COATS OF
CONCRETE SEALER, POLYURETHANE PAINT FINISH
ON BOTH FACE.

25 X 50 MM BLACK IRON TUBULAR FLAT
AUTOMOTIVE LAGUER PAINT FINISH ON
2 COATS OF EPOXY PRIMER

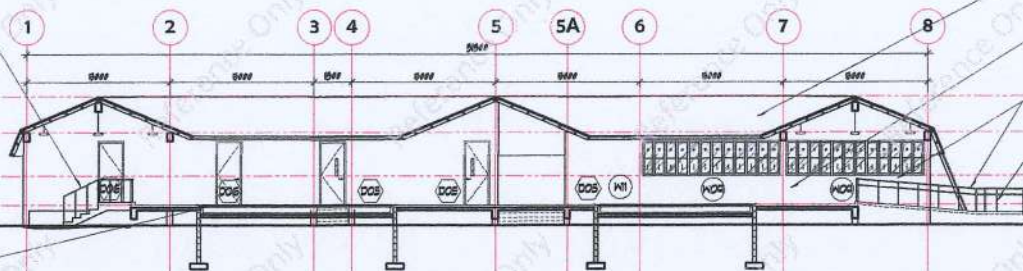25 X 50 MM BLACK IRON TUBULAR SPACED @ 700
MM ON CENTER FLAT AUTOMOTIVE LAGUER PAINT
FINISH ON 2 COATS OF EPOXY PRIMER



4 SECTION THRU D-D
SCALE: 1/200 M.

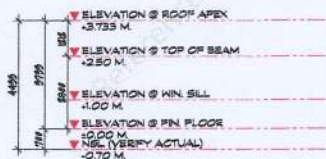
150 MM THK CONCRETE HOLLOW BLOCK
WALL W/ 25 MM THK CEMENT PLASTER
WITH 2 COATS OF CONCRETE SEALER,
POLYURETHANE PAINT FINISH ON BOTH
FACE.

STEEL GRATING TRENCH DRAIN

FABRICATED CONCRETE COUNTER
WITH 300 X 300 MM HOMOGENOUS
TILES FINISH

OUTDOOR LAB

50 MM THK PRECAST CONCRETE WITH
2 COATS OF CONCRETE SEALER,
POLYURETHANE PAINT FINISH





**JORGE YULO
ARCHITECTS &
ASSOCIATES**

3rd Floor Automatic Center Bldg.
2207 Don Chino Reyes Ave. Davao
Del Norte City, Philippines 8201
Telephone No. (832) 8482144
8482074
Fax No. (832) 8482074

Email Address:
jyulo@jyulo.com
jyulo_arch@jyulo.com
URL Address:
http://www.jyulo.com

PTF NO.: 10475571 REG. NO.: 12396

ISSUED ON: JAN 08, 2025 TIN NO.: 102-325-935

ISSUED AT: NAKATI CITY

JORGE MANUEL B. YULO
ARCHITECT

ENGINEER

PTF NO.: REG. NO.:

ISSUED ON: JAN 08, 2025 TIN NO.:

ISSUED AT:

PROJECT TITLE:
**PROPOSED
MARINE SCIENTIFIC
RESEARCH
STATION**

LOCATION:
**BRGY. DIBACONG,
CASIGURAN, AURORA,
PHILIPPINES**

 
OWNER:
MR. ALFREDO B. COLLADO

SHEET CONTENTS:

**REFLECTED
CEILING
PLAN**


DATE:
MARCH 2025

DRAWN BY: STL CHECKED BY: RPA3



SHEET NO.:

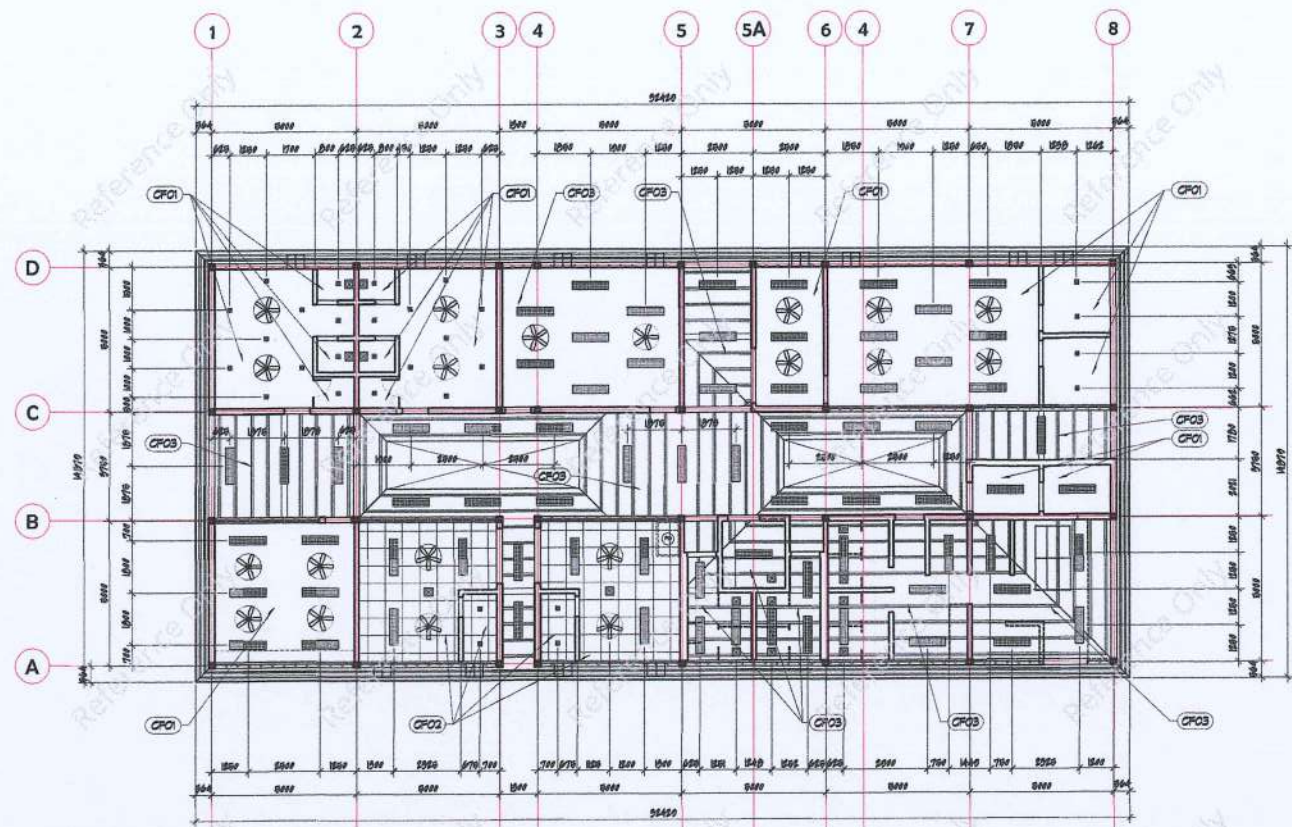A-6



CEILING FINISHES:

- CPO1** 4.5 MM THK. FIBER CEMENT BOARD CEILING ON METAL PURING CHANNELS, FLAT LATEX PAINT FINISH
- CPO2** 600 X 600 MM ACOUSTIC CEILING TILE ON T-RUNNER
- CPO3** EXPOSED UNDER ROOF CEILING

ELECTRICAL LEGEND:

- TROFFER LIGHTING FIXTURE (2-36 WATTS FLUORESCENT)
- EXHAUST FAN
- LABORATORY FUME HOOD
- 10 WATTS LED RECESSED PIN LIGHT
- OSCILLATING CEILING FAN

1 REFLECTED CEILING PLAN
A-6 SCALE: 1/20 M.

MSRS_Aurora_p.7

PLAN (001) ELEV. (001)	PLAN (002) ELEV. (002)	PLAN (003) ELEV. (003)	PLAN (004) ELEV. (004)	PLAN (005) ELEV. (005)	PLAN (006) ELEV. (006)	PLAN (007) ELEV. (007)	PLAN (008) ELEV. (008)
DO1 THREE (3) SETS RECEIVING LABORATORIES SOLID CORE DOUBLE SWING DOOR WITH 6MM THK NARROW LITE ON BOTH LEAF ON A FR. 50 X 100 DOOR JAMB FRAME, FLAT BLACK PAINT FINISH	DO2 ONE (1) SET EQUIPMENT & DRYING AREA SOLID CORE DOUBLE SWING DOOR WITH 6MM THK NARROW LITE ON BOTH LEAF ON A FR. 50 X 100 DOOR JAMB FRAME, FLAT BLACK PAINT FINISH	DO3 ONE (1) SET STAFF OFFICE SOLID CORE SINGLE SWING DOOR WITH 6MM THK NARROW LITE ON A FR. 50 X 100 DOOR JAMB FRAME, FLAT BLACK PAINT FINISH	DO4 TWO (2) SETS LABORATORY STORAGE ROOMS SINGLE SWING METAL DOOR WITH 6MM THK NARROW LITE ON A FR. 50 X 100 DOOR JAMB FRAME, FLAT BLACK PAINT FINISH	DO5 SEVEN (7) SETS SERVER, ELEC. DR. & OFFICE STORAGE SOLID CORE SINGLE SWING DOOR WITH 6MM THK NARROW LITE ON A FR. 50 X 100 DOOR JAMB FRAME, FLAT BLACK PAINT FINISH	DO6 FOUR (4) SETS QUARTERS & GUARD HOUSE SOLID CORE SINGLE SWING DOOR ON A FR. 50 X 100 DOOR JAMB FRAME, FLAT BLACK PAINT FINISH	DO7 ONE (1) SET KITCHEN & MESS HALL 6MM THK SINGLE SWING ALUMINUM FRAMED GLASS DOOR, BLACK ANALOG FINISH	DO8 ONE (1) SET PWD TOILET SOLID CORE SINGLE SWING DOOR WITH 15 MM THK STAINLESS STEEL KICK PLATE ON 50 X 100 DOOR JAMB FRAME, FLAT BLACK PAINT FINISH
PLAN (009) ELEV. (009)	PLAN (010) ELEV. (010)	PLAN (011) ELEV. (011)	PLAN (012) ELEV. (012)	PLAN (013) ELEV. (013)	NOTE: - VERIFY ACTUAL DIMENSIONS ON SITE PRIOR TO FABRICATION OF DOORS AND WINDOWS. - VERIFY GLASS THICKNESS W/ THE SUPPLIER AND/OR MANUFACTURER CONTRACTOR TO SUBMIT MOCK UP PRIOR TO FABRICATION OF DOORS AND WINDOWS.		
DO9 TWO (2) SETS MALE AND FEMALE TOILET SOLID CORE SINGLE SWING DOOR WITH 15 MM THK ES KICK PLATE ON 50 X 100 DOOR JAMB FRAME, FLAT BLACK PAINT FINISH	DO10 FIVE (5) SETS TES @ LODGING AND GUARDHOUSE HOLLOW CORE SINGLE SWING DOOR ON A FR. 50 X 100 DOOR JAMB FRAME, FLAT BLACK PAINT FINISH	DO11 EIGHT (8) SETS SHOWER & TOILET @ EQPT/DRYING AREA 12MM THK HIGH PRESSURE LAMINATE (VERIFY TYPE)	DO12 THREE (3) SETS TRANSFORMER, GENSET & PUMP ROOM 50 X 100 X 15 MM THK LOUVERED STEEL DOUBLE SWING DOOR ON 50 X 100 STEEL JAMB, FLAT BLACK PAINT FINISH	DO13 THREE (3) SETS QUARTERS AND OFFICE STORAGE 12MM THK HIGH PRESSURE LAMINATE (VERIFY TYPE)			

1 DOORS & WINDOWS SCHEDULE
A-7 SCALE: 1/50 M.

MSRS_Aurora_p.8

JORGE YULO ARCHITECTS & ASSOCIATES

3rd Floor Aduarte Center Bldg.
2207 Don Chino Rocas Ave. East,
Makati City - Philippines 1211
Telephone Nos. (02) 8452344
8452374
Fax No. (02) 8452374

Email Address:
jyulo@jorgeyulo.com
jyulo_arch@jorgeyulo.com
URL: <http://www.jorgeyulo.com>

PROJECT NO.: 10475571 REG. NO.: 12396
ISSUED ON: JAN 08, 2025 TIT. NO.: 102-325-935
ISSUED AT: MNGATI CITY

JORGE MANUEL B. YULO
ARCHITECT

ENGINEER

PROJECT TITLE:
PROPOSED
MARINE SCIENTIFIC
RESEARCH
STATION

LOCATION:
BRGY. DIBACONG
CAGSUGURAN, AURORA,
PHILIPPINES

OWNER:
MR. ALFREDO B. COLLADO

SHEET CONTENTS:
DOORS AND WINDOWS
SCHEDULE

DATE:
MARCH 2025

DRAWN BY: ETL CHECKED BY: PPAAS

GRAPHIC SCALE:
1:50 METERS
1:100 METERS
1:200 METERS
1:500 METERS
1:1000 METERS

SHEET NO.:
A-7

PLAN ELEV.	PLAN ELEV.	PLAN ELEV.	PLAN ELEV.	PLAN ELEV.
W01 FOUR (4) SETS (M/P) TOILETS AND LAUNDRY AREAS 6MM THK CLEAR GLASS AWNING WINDOW (TOP) AND BLACK FIXED ALUMINUM COMPOSITE PANELS (BOT) IN BLACK ANALOK ALUMINUM FRAME	W02 THREE (3) SETS KITCHEN & MESS HALL, DIR. OFFICE, AND STAFF STORAGE 6MM THK CLEAR GLASS AWNING WINDOW (BOT) AND BLACK FIXED ALUMINUM COMPOSITE PANELS (TOP) IN BLACK ANALOK ALUMINUM FRAME	W03 THREE (3) SETS LABORATORIES AND CONFERENCE ROOM 6MM THK CLEAR GLASS FIXED AND AWNING WINDOW IN BLACK ANALOK ALUMINUM FRAME WITH ACCU ENCLOSURE	W04 TWO (2) SETS LODGING 1 AND 2 6MM THK CLEAR GLASS FIXED AND AWNING WINDOW IN BLACK ANALOK ALUMINUM FRAME WITH ACCU ENCLOSURE	W05 ONE (1) SET RECEIVING AREA 6MM THK CLEAR GLASS FIXED AND AWNING WINDOW IN BLACK ANALOK ALUMINUM FRAME WITH ACCU ENCLOSURE
PLAN ELEV.	PLAN ELEV.	PLAN ELEV.	PLAN ELEV.	PLAN ELEV.
W06 TWO (2) SETS LODGING 1 AND 2 6MM THK CLEAR GLASS FIXED AND AWNING WINDOW IN BLACK ANALOK ALUMINUM FRAME WITH ACCU ENCLOSURE	W07 ONE (1) SET STAFF OFFICE 6MM THK CLEAR GLASS FIXED AND AWNING WINDOW IN BLACK ANALOK ALUMINUM FRAME	W08 ONE (1) SET EQUIPMENT & DRYING AREA 6MM THK CLEAR GLASS FIXED AND AWNING WINDOW IN BLACK ANALOK ALUMINUM FRAME	W09 FOUR (4) SETS LABORATORIES, STAFF OFFICE AND STORAGE ROOM 6MM THK CLEAR GLASS SINGLE HUNG WINDOW IN BLACK ANALOK ALUMINUM FRAME	W10 ONE (1) SET MESS HALL / KITCHEN 6MM THK CLEAR GLASS SINGLE HUNG WINDOW IN BLACK ANALOK ALUMINUM FRAME
PLAN ELEV.	PLAN ELEV.	PLAN ELEV.	PLAN ELEV.	PLAN ELEV.
W11 ONE (1) SET GUARD HOUSE 6MM THK CLEAR GLASS SINGLE HUNG WINDOW IN BLACK ANALOK ALUMINUM FRAME	W12 ONE (1) SET P.WD TOILET 6MM THK CLEAR GLASS AWNING WINDOW IN BLACK ANALOK ALUMINUM FRAME	W13 ONE (1) SET GUARDHOUSE 6MM THK CLEAR GLASS AWNING WINDOW (TOP) AND BLACK FIXED ALUMINUM COMPOSITE PANELS (BOT) IN BLACK ANALOK ALUMINUM FRAME	W14 ONE (1) SET GUARDHOUSE TOILET 6MM THK CLEAR GLASS AWNING WINDOW (TOP) AND BLACK FIXED ALUMINUM COMPOSITE PANELS (BOT) IN BLACK ANALOK ALUMINUM FRAME	W15 ONE (1) SET CONFERENCE ROOM 6MM THK CLEAR GLASS FIXED AND AWNING WINDOW IN BLACK ANALOK ALUMINUM FRAME

1 DOORS & WINDOWS SCHEDULE
SCALE: 1/50 M.

MSRS_Aurora_p.9

JORGE YULO ARCHITECTS & ASSOCIATES

3rd Floor Antelina Center Bldg.
2257 Don Chino Reyes Ave. Cebu
Mandaluyod City, Philippines 1211
Telephone Nos. (803) 8452344
8452374
Fax No. (803) 8452374
Email Address:
jyulo@jyuloarchitects.com
jyulo@jyuloarchitects.com
URL Address:
http://www.jyuloarchitects.com

PTB NO.: 10475571
REG. NO.: 12376
ISSUED ON: JAN 08, 2025
TIN NO.: 102-325-935

ISSUED AT:
MAGATI CITY

JORGE MANUEL B. YULO
ARCHITECT

ENGINEER

PTB NO.:
REG. NO.:
ISSUED ON:
TIN NO.:

ISSUED AT:

PROJECT TITLE:
PROPOSED MARINE SCIENTIFIC RESEARCH STATION

LOCATION:

BRY, DIBACONG, CASIGURAN, AURORA, PHILIPPINES

OWNER:

MR. ALFREDO B. COLLADO

SHEET CONTENTS:
DOORS AND WINDOWS SCHEDULE

DATE:

MARCH 2025

DESIGNED BY: CHECKED BY:

ETL. PFBAS

GRAPHIC SCALE:

1:50 METERS

1:100 METERS

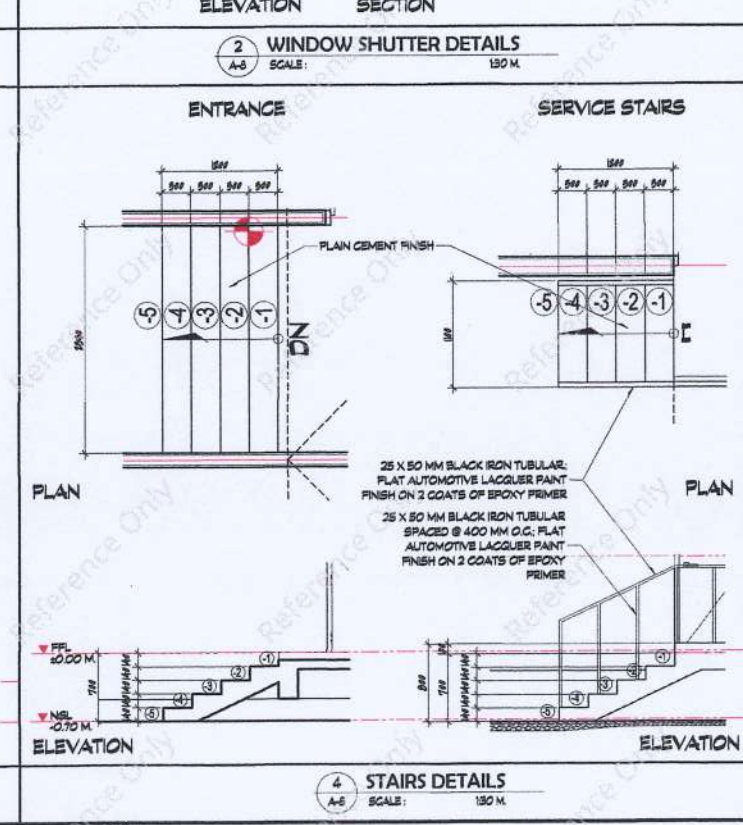
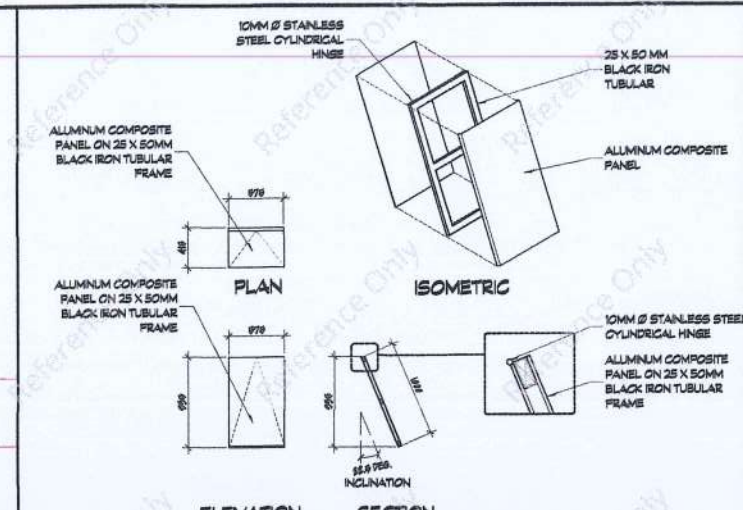
1:200 METERS

1:500 METERS



1:1000 METERS

SHEET NO.:

A-7A



 JORGE YULO ARCHITECTS & ASSOCIATES	
3rd Floor Automobile Center Bldg. 2357 Don Chino Rivera Ave. Edif. August 2nd, Philippines 1201 Telp. No. (02) 4492574 Fax No. (02) 4492574	
Email Address: jyuloarchitects@jorgeyulo.com.ph info@jorgeyulo.com.ph URL: www.jorgeyulo.com.ph	
PTR NO.: 10475571	REG. NO.: 12796
ISSUED ON: JAN 08, 2025	TIN NO.: 102-325-935
DESIGNED AT: MAKATI CITY	
JORGE MANUEL B. YULO ARCHITECT	
ENGINEER	
PTR NO.:	REG. NO.:
ISSUED ON:	TIN NO.:
DESIGNED AT:	
PROJECT TITLE: PROPOSED MARINE SCIENTIFIC RESEARCH STATION	
LOCATION: BRYC DIBACANG, CASIGURAN, AURORA, PHILIPPINES	
OWNER: MR. ALFREDO B. COLLADO	
SHEET CONTENTS: WIND DEFLECTOR, WINDOW SHUTTERS, RAMP AND STAIR DETAILS	
DATE: MARCH 2025	
DRAWN BY: ETL	CHECKED BY: PHAB
GRAPHIC SCALE: 	
SHEET NO.: A-8	

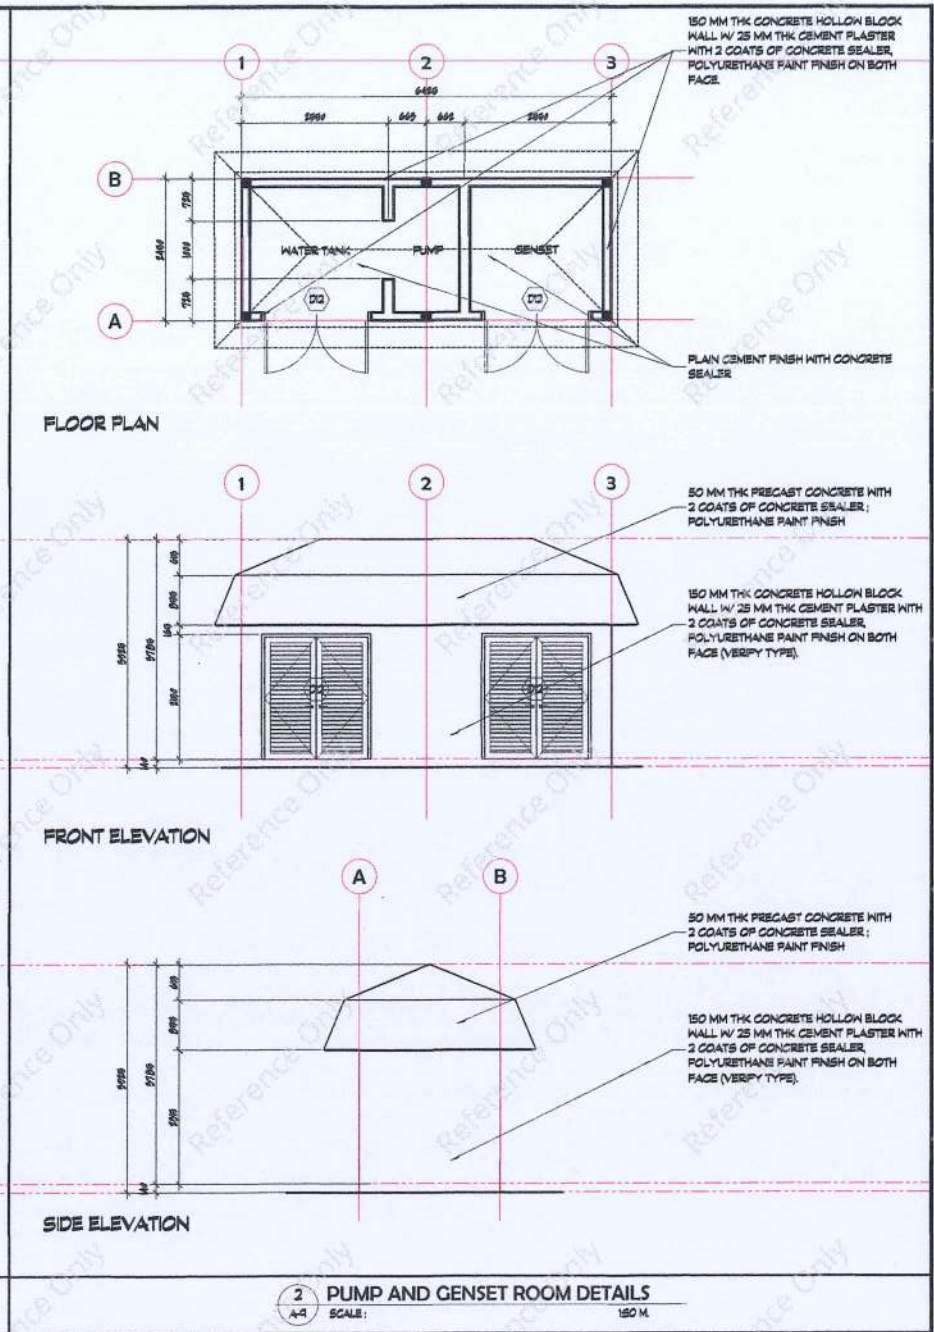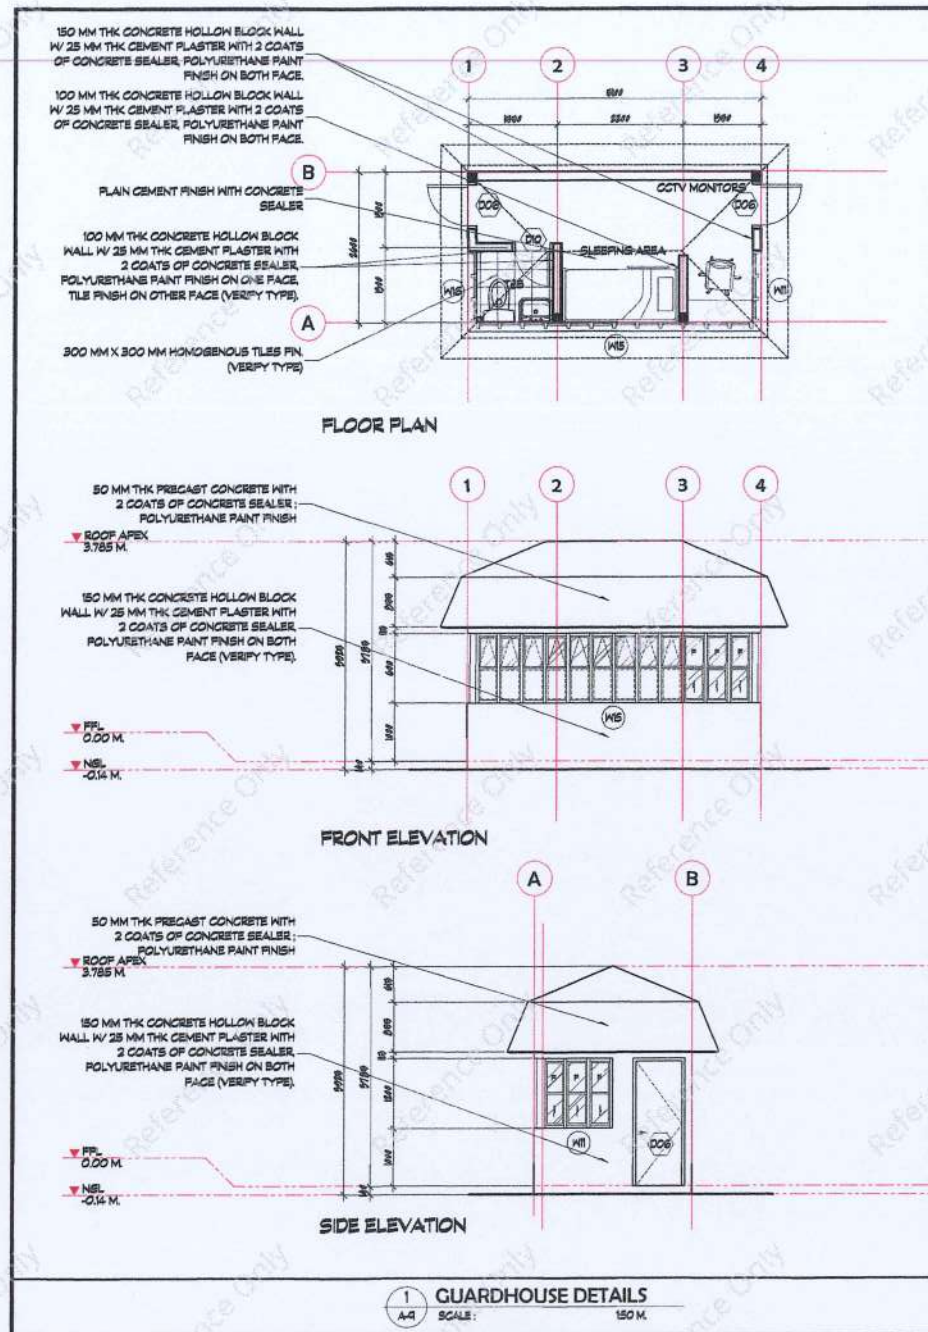

JORGE YULO ARCHITECTS & ASSOCIATES

3rd Floor Automatic Center Bldg.
2207 Don Chino Rivera Ave. Cebu
Makati City, Philippines 1211
Telephone No. (832) 842124
842074
Fax No. (832) 842074

Email Address:
jyulo@jyulo.com
jyulo.jyulo@jyulo.com
URL Address:
www.jyulo.com

PTR NO.: 10475571 REG. NO.: 12396
ISSUED ON: JAN 08, 2025 TYN NO.: 102-325-935
JULIUS AT: MAKATI CITY

JORGE MANUEL B. YULO
ARCHITECT

ENGINEER

PTR NO.: REG. NO.:
ISSUED ON: TYN NO.:
JULIUS AT:

PROJECT TITLE:
PROPOSED
MARINE SCIENTIFIC
RESEARCH
STATION

LOCATION:
BRGY. DIBACONG,
CASIGURAN, AURORA,
PHILIPPINES

OWNER:
MR. ALFREDO S. COLLADO

SHEET CONTENTS:
GUARD HOUSE, PUMP
ROOM AND GENSET ROOM
DETAILS

DATE:
MARCH 2025

DRAWN BY: ETL CHECKED BY: RPAS

GRAPHIC SCALE:
1:50 METERS
1:100 METERS
1:200 METERS
1:500 METERS
1:1000 METERS

SHEET NO.:
A-9



Department of Environment and Natural Resources

ARCHITECTURAL DESIGN

ALABEL, SARANGANI

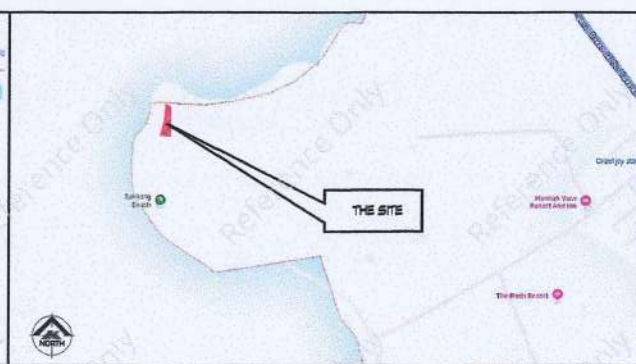
MARINE SCIENTIFIC RESEARCH STATION



1 PERSPECTIVES
SCALE: N.T.S.



2 VICINITY MAP
SCALE: N.T.S.



3 LOCATION MAP
SCALE: N.T.S.

TABLE OF CONTENTS

ARCHITECTURAL	ELECTRICAL
CS-1 PERSPECTIVES	
A-1 SITE LOCATION MAP	
A-2 FLOOR PLAN	
A-3 ROOF PLAN	
A-4 ELEVATIONS	
A-5 SECTIONS	
A-6 REFLECTED CEILING PLAN	
A-7 DOORS AND WINDOWS SCHEDULE	
A-7a DOORS AND WINDOWS SCHEDULE	
A-7b WINDOWS SCHEDULE	
A-8 WINDOW DEFLECTOR, WINDOW SHUTTER DETAILS	
A-8 RAMP AND STAIR DETAILS	
A-9 PUMP ROOM DETAILS	
A-9 GUARD HOUSE, AND SENSIT ROOM DETAILS	

STRUCTURAL

MECHANICAL

SANITARY

REPUBLIC OF THE PHILIPPINES
DEPARTMENT OF PUBLIC WORKS
AND HIGHWAYS
OFFICE OF THE BUILDING OFFICIAL

LAND USE/ZONING

LINE AND GRADE

ARCHITECTURAL

STRUCTURAL

SANITARY

ELECTRICAL

MECHANICAL



JORGE YULO ARCHITECTS & ASSOCIATES
3F Suburban Center, 2009 Don
Chato Street, Alabell, Sarangani
City, Philippines 7002
Telephone No. (032) 848074
Fax No. (032) 848074
Email Address: july_mco@joryulo.com
URL Address: http://www.joryulo.com

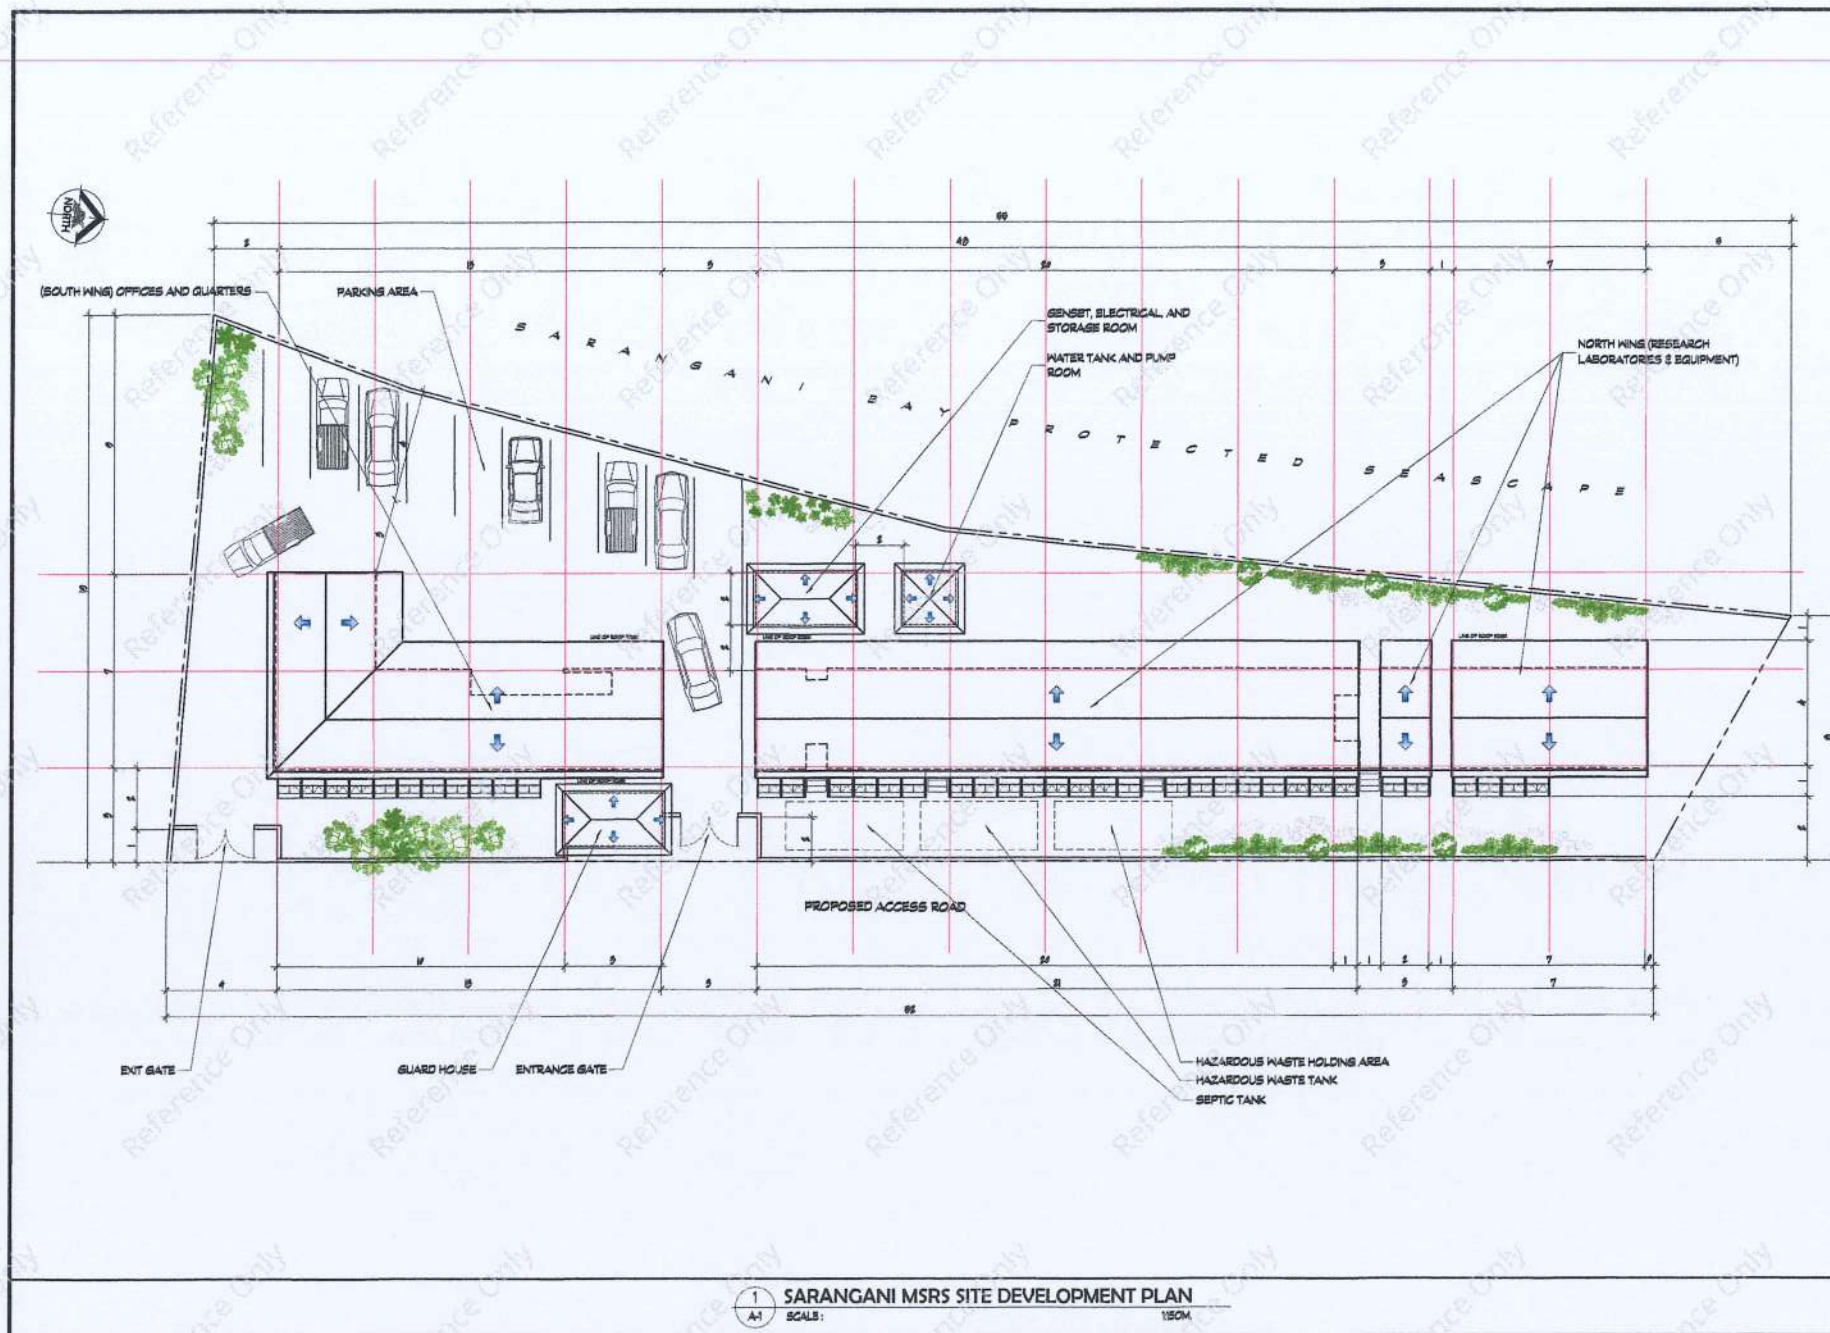
PTR NO.: 10475571 REG. NO.: 12396
ISSUED ON: JAN. 08, 2025 TIN NO.: 102-325-935
ISSUED AT: MAKATI CITY
JORGE MANUEL B. YULO
ARCHITECT

ENGINEER
PTR NO.: REG. NO.:
ISSUED ON: TIN NO.:
ISSUED AT:

PROJECT TITLE:
PROPOSED MARINE SCIENTIFIC
RESEARCH STATION
LOCATION:
LEBAKIN, BRGY. KAWAS,
ALABEL, SARANGANI,
PHILIPPINES

OWNER:
ATTY. FELIX S. ALICER

SHEET CONTENTS:
PERSPECTIVES
VICINITY MAP
LOCATION MAP
DATE: JUNE 2025
DRAWN BY: ETL CHECKED BY: ETL
GRAPHIC SCALE:
1:25 METERS
0 25 50 75 100
1:50 METERS
0 50 100 150 200
1:100 METERS
0 100 200 300 400
SHEET NO.: CS-1



1 SARANGANI MSRS SITE DEVELOPMENT PLAN
SCALE: 1:50M

MSRS_Sarangani_p.2

JORGE YULO ARCHITECTS & ASSOCIATES

2nd Floor Antares Office Center Bldg.
2201 Quezon Avenue, Suite 201
Makati City, Philippines 1221
Telephone No. (832) 882034
Fax No. (832) 882074
Email Address: jorgeyulo@jorgeyulo.com
jorge.yulo@jorgeyulo.com
URL Address: http://www.jorgeyulo.com

PTB NO.: 10475571 REG. NO.: 12396
ISSUED ON: JAN 08, 2025 TIN NO.: 102-325-935

ISSUED AT: MANKATI CITY

JORGE MANUEL B. YULO
ARCHITECT

ENGINEER

PTB NO.: REG. NO.:

ISSUED ON: TIN NO.:

ISSUED AT:

PROJECT TITLE:
PROPOSED MARINE SCIENTIFIC RESEARCH STATION

LOCATION:
LEBAKIN, BRGY. KAWAS, ALABEL, SARANGANI, PHILIPPINES

OWNER:
ATTY. FELIX S. ALICER

SHEET CONTENTS:
SITE DEVELOPMENT PLAN

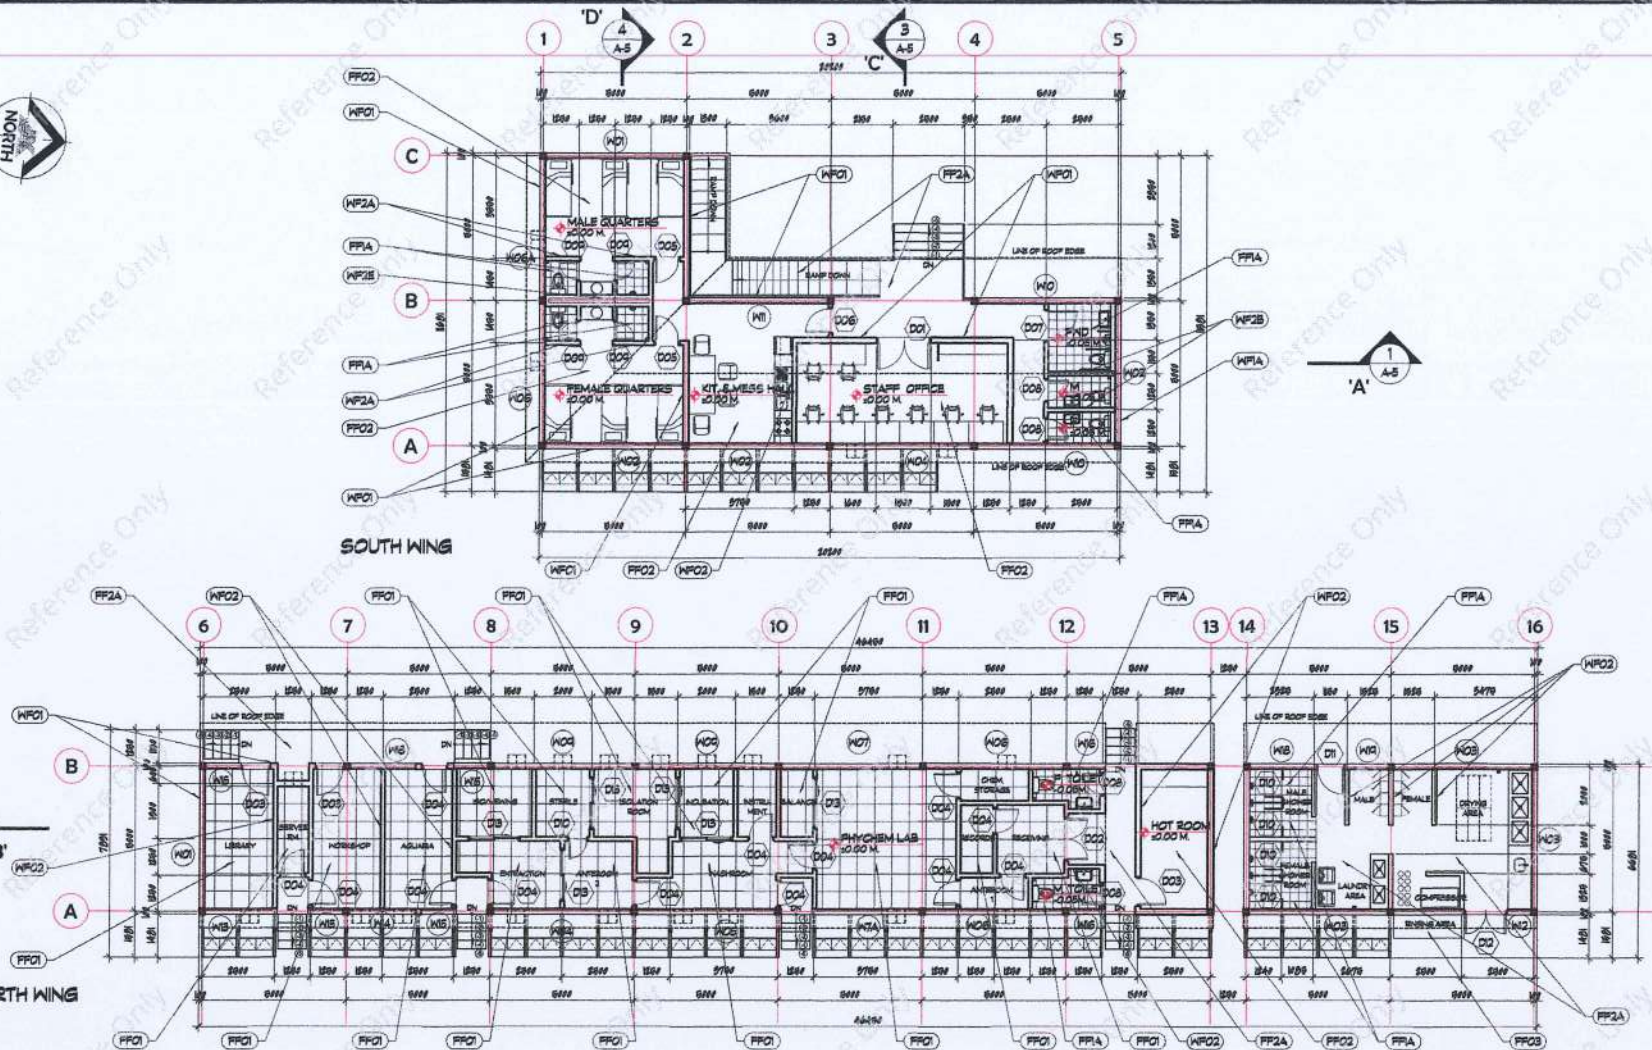
 
DATE:
JUNE 2025

DRAWN BY: ETL CHECKED BY: PPS

GRAPHIC SCALE:
1:50 METERS
1:100 METERS
1:200 METERS
1:500 METERS
1:1000 METERS

SHEET NO.:

A-1



A-2

(NF-01) 150 MM THK CONCRETE HOLLOW BLOCK WALL IV 25 MM THK CEMENT PLASTER WITH 2 COATS OF CONCRETE SEALER. POLYURETHANE PAINT FINISH ON BOTH FACE.

(NF-1A) 150 MM THK CONCRETE HOLLOW BLOCK WALL IV 25 MM THK CEMENT PLASTER WITH 2 COATS OF CONCRETE SEALER. POLYURETHANE PAINT FINISH ON ONE FACE. TILE FINISH ON OTHER FACE (VERIFY TYPE).

(NF-1B) 150 MM THK CONCRETE HOLLOW BLOCK WALL, TILE FINISH ON BOTH FACE (VERIFY TYPE).

(NF-02) 100 MM THK CONCRETE HOLLOW BLOCK WALL IV 25 MM THK CEMENT PLASTER WITH 2 COATS OF CONCRETE SEALER. POLYURETHANE PAINT FINISH ON BOTH FACE.

(NF-20)	100 MM THK CONCRETE HOLLOW BLOCK WALL, 1/4 25 MM THK CEMENT PLASTER NTH 2 COATS OF CONCRETE SEALER, POLYURETHANE PAINT FINISH ON ONE FACE, TILE FINISH ON OTHER FACE (VERIFY TYPE).
(NF-28)	100 MM THK CONCRETE HOLLOW BLOCK WALL, TILE FINISH ON BOTH FACE (VERIFY TYPE).
(NF-30)	275 MM THK (2-100 MM) CONCRETE HOLLOW BLOCK WALL, 25 MM THK CEMENT PLASTER NTH 2 COATS OF CONCRETE SEALER, POLYURETHANE PAINT FINISH ON ONE FACE, TILE FINISH ON OTHER FACE (VERIFY TYPE).
(NF-2D)	275 MM THK (2-100 MM) CONCRETE HOLLOW BLOCK WALL, TILE FINISH ON BOTH FACE (VERIFY TYPE).

(NF-2E) 400 MM THK (2-100 MM) CONCRETE HOLLOW BLOCK WALL
TILE FINISH ON BOTH FACE (VERIFY TYPE)

(NF-03) 50 MM THK PRECAST CONCRETE WITH 2 COATS OF CONCRETE
SEALER : POLYURETHANE PAINT FINISH

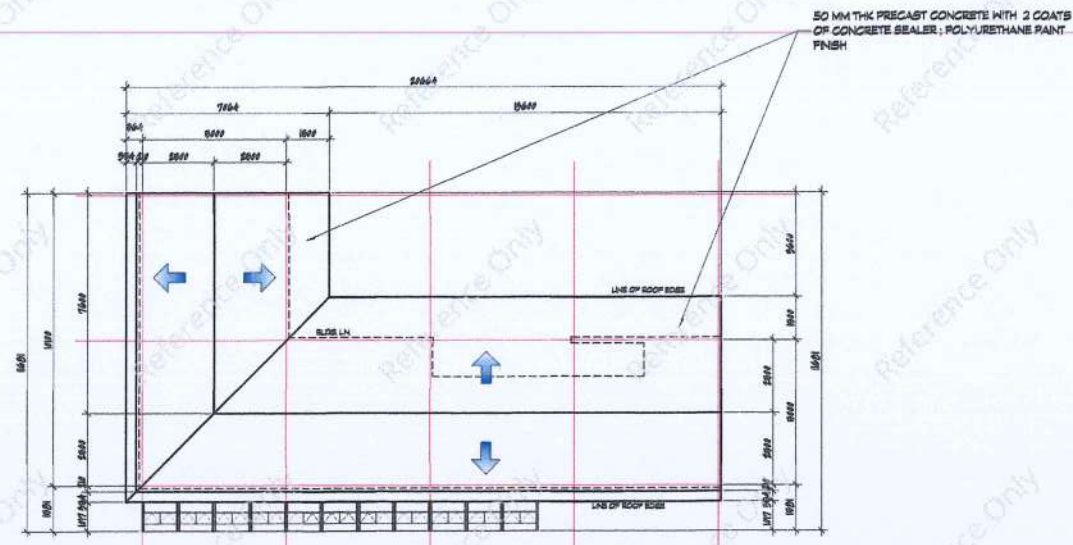
(NF-04) ALUMINUM COMPOSITE PANEL ON METAL FRAME

(NF-05) 12 MM THK HIGH PRESSURE LAMINATE (VERIFY TYPE)


- (FF-01) 600 MM X 600 MM HOMOGENEOUS
TILES FIN. (VERIFY TYPE)
- (FF-1A) 300 MM X 300 MM HOMOGENEOUS TILES FIN.
(VERIFY TYPE)
- (FF-02) SANDED TO SMOOTH PLAIN CEMENT
FINISH WITH CONCRETE SEALER & 3
COATS OF POLYURETHANE PAINT
- (FF-2A) PLAIN CEMENT CONCRETE FINISH
- (FF-03) 50MM THK RIVER STONE GRAVEL BED

1 NORTH AND SOUTH WING FLOOR PLAN

MSRS_Sarangani_p.3



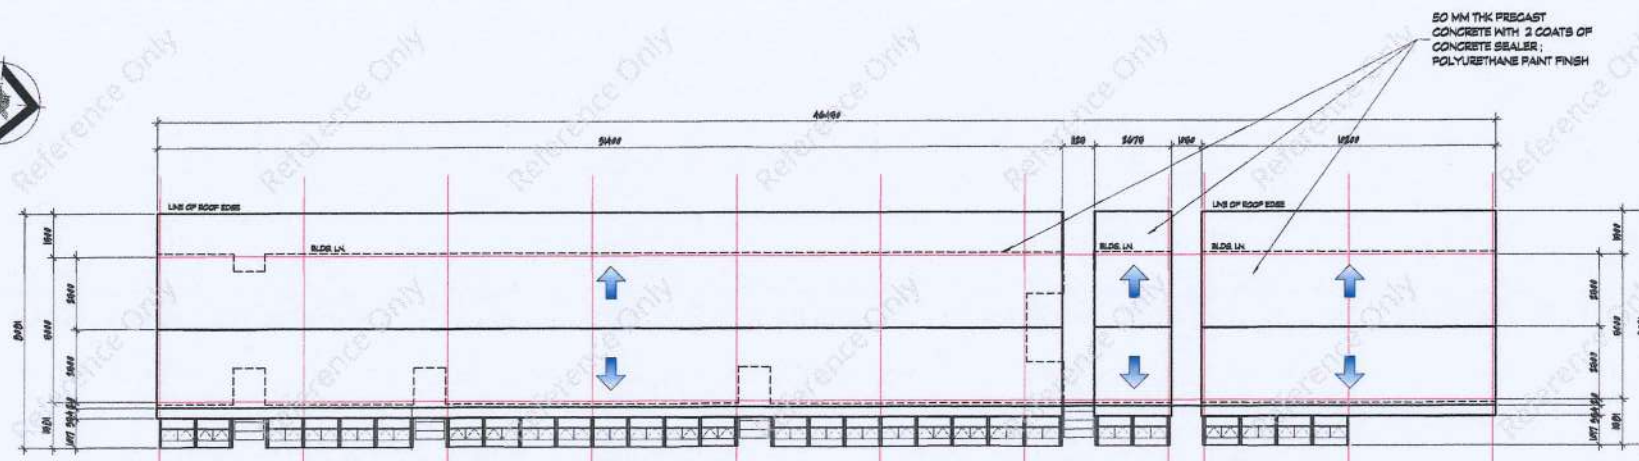1 SOUTH WING ROOF PLAN
A-3 SCALE: 1/8" = 1'-0"



2 NORTH WING ROOF PLAN
A-3 SCALE: 1/8" = 1'-0"

ENGINEER

PTR NO.	REG. NO.
ISSUED ON:	TIN NO:
ISSUED AT:	

PROJECT TITLE:
PROPOSED
MARINE SCIENTIFIC
RESEARCH
STATION

LOCATION :
LEBAKUN, BRGY. KAWAS
ALABEL,
SARANGANI,
PHILIPPINES

OWNER:
ATTY. FELIX S. ALICER

SHEET CONTENTS:

ROOF PLAN

DATE: _____

Debit	Credit
-------	--------

CRIMINAL SCALE:

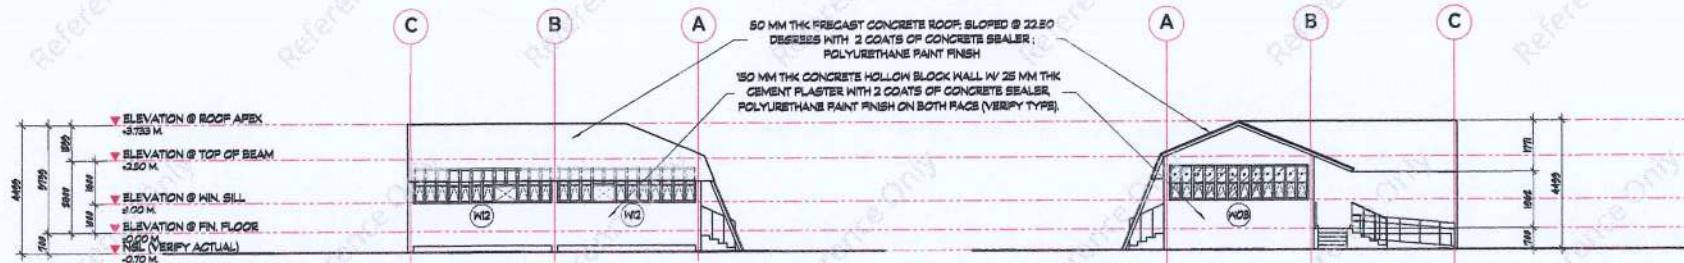
0.50

0.52 1.00
0.125 0.25

SHEET NO. -


10

A-3




1 SOUTH WING LEFT SIDE ELEVATION
SCALE: 1/100 M

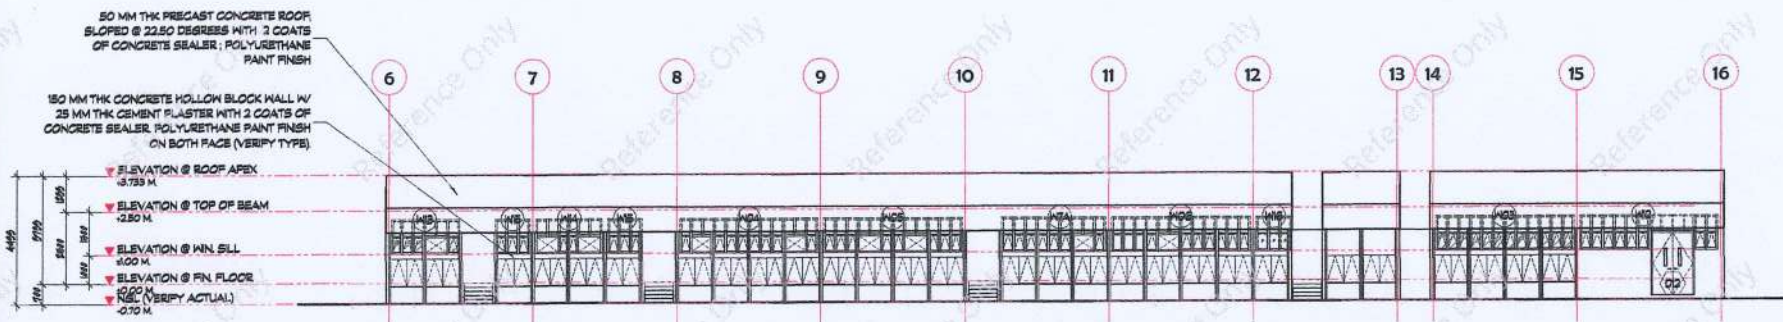2 NORTH WING RIGHT SIDE ELEVATION
SCALE: 1/100 M



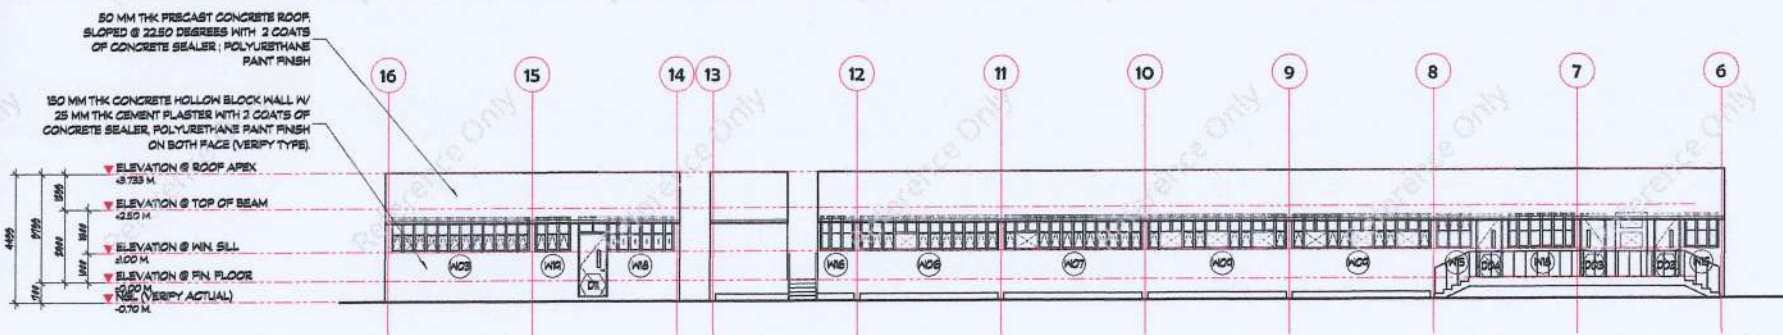3 NORTH WING FRONT ELEVATION
SCALE: 1/100 M



4 NORTH WING REAR ELEVATION
SCALE: 1/100 M

JORGE YULO ARCHITECTS & ASSOCIATES

3rd Floor, Aureliana Center Bldg,
2257 Don Chino Rocas Ave. Davao,
8100 Davao City, Philippines 8121
Telephone No. (833) 8452344
Fax No. (833) 8452374
Email Address: jorgeyulo@jorgeyulo.com
jorge_yulo@jorgeyulo.com
URL Address: http://www.jorgeyulo.com

PTIR NO.: 10475571 REG. NO.: 12376
ISSUED ON: JAN 08, 2025 TEN NO.: 102-325-935

ISSUED AT: MAKATI CITY

JORGE MANUEL B. YULO
ARCHITECT

ENGINEER
PTIR NO.: REG. NO.:
ISSUED ON: TEN NO.:
ISSUED AT:

PROJECT TITLE:
PROPOSED MARINE SCIENTIFIC
RESEARCH STATION

LOCATION:
LEBAKUN, BANGI, KAWAS,
ALABEL, SARANGANI,
PHILIPPINES

OWNER:
ATTY. FELIX S. ALICER

SHEET CONTENTS:
ELEVATIONS

DATE:
JUNE 2025
DRAWN BY: ETL CHECKED BY: PFA3

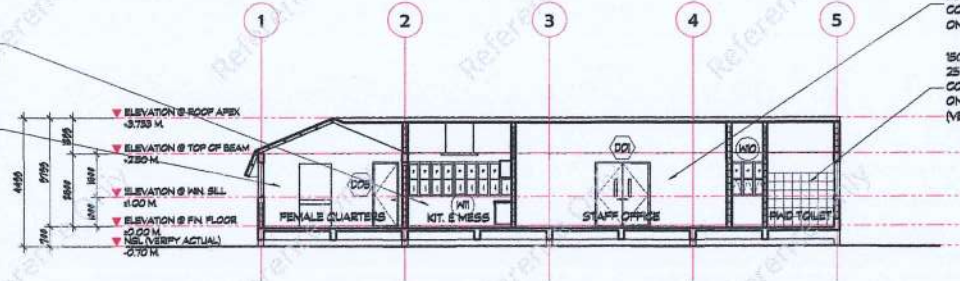
GRAPHIC SCALE:
1:50 METERS
1:100 METERS
1:150 METERS
1:200 METERS

SHEET NO.:

A-4

150 MM THK CONCRETE HOLLOW BLOCK WALL W/ 25 MM THK CEMENT PLASTER WITH 2 COATS OF CONCRETE SEALER, POLYURETHANE PAINT FINISH ON BOTH FACE (VERIFY TYPE).


100 MM THK CONCRETE HOLLOW BLOCK WALL W/ 25 MM THK CEMENT PLASTER WITH 2 COATS OF CONCRETE SEALER, POLYURETHANE PAINT FINISH ON ONE FACE, TILE FINISH ON OTHER FACE (VERIFY TYPE).




150 MM THK CONCRETE HOLLOW BLOCK WALL W/ 25 MM THK CEMENT PLASTER WITH 2 COATS OF CONCRETE SEALER, POLYURETHANE PAINT FINISH ON BOTH FACE (VERIFY TYPE).

150 MM THK CONCRETE HOLLOW BLOCK WALL W/ 25 MM THK CEMENT PLASTER WITH 2 COATS OF CONCRETE SEALER, POLYURETHANE PAINT FINISH ON ONE FACE, TILE FINISH ON OTHER FACE (VERIFY TYPE).

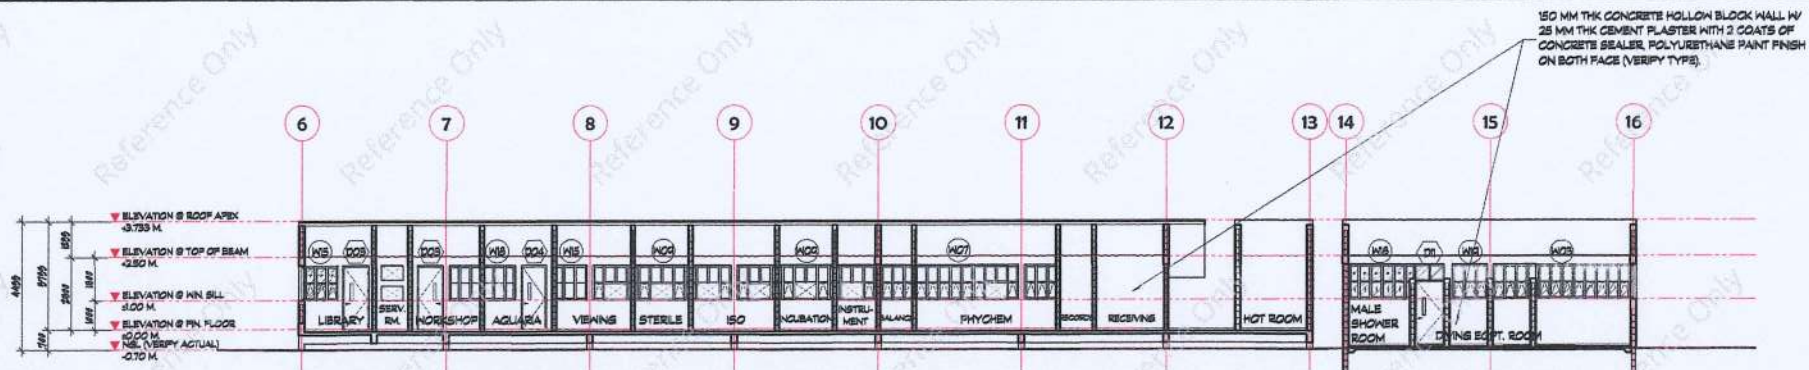1 SECTION THRU A-A
A-B SCALE: 1/200 M.




2 SECTION THRU B-B
A-B SCALE: 1/100 M.

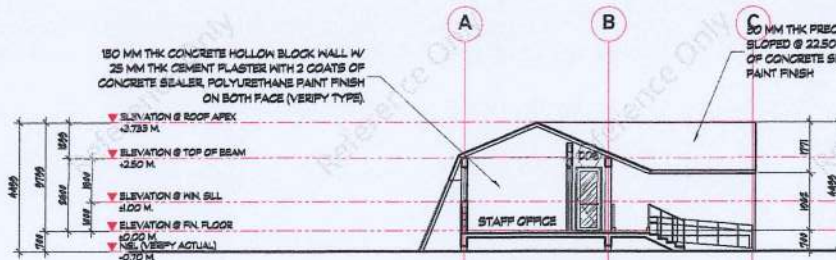

3 SECTION THRU C-C
A-B SCALE: 1/100 M.

400 MM THK (2-100 MM) CONCRETE HOLLOW BLOCK WALL, TILE FINISH ON BOTH FACE (VERIFY TYPE).

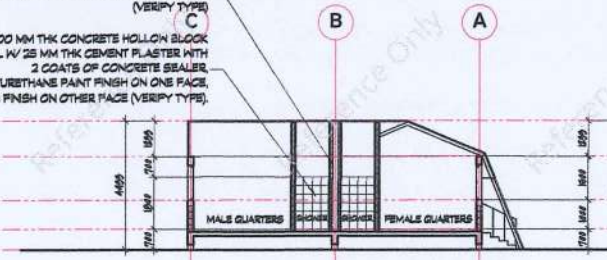100 MM THK CONCRETE HOLLOW BLOCK WALL W/ 25 MM THK CEMENT PLASTER WITH 2 COATS OF CONCRETE SEALER, POLYURETHANE PAINT FINISH ON ONE FACE, TILE FINISH ON OTHER FACE (VERIFY TYPE).



4 SECTION THRU D-D
A-B SCALE: 1/100 M.

JORGE YULO ARCHITECTS & ASSOCIATES

3rd Floor, Asean Center, Bldg. 2257, Das Office Plaza, Ave. 12th, Makati City, Philippines 1227
Telephone No. (02) 8857534
Fax No. (02) 8857574
Email Address: jarchitects@gmail.com
jyulo.jarchitects@gmail.com
URL Address: http://www.jorgeyulo.com

PTR NO.: 10475571 REG. NO.: 12396
ISSUED ON: JAN 08, 2025 TIN NO.: 102-325-935
DESIGNED AT: MAKATI CITY

JORGE MANUEL B. YULO
ARCHITECT

ENGINEER

PTR NO.: REG. NO.:
ISSUED ON: TIN NO.:
DESIGNED AT:

PROJECT TITLE:
PROPOSED MARINE SCIENTIFIC RESEARCH STATION

LOCATION:
LEBAKUN, BRGY. KAWAS, ALABEL, SARANGANI, PHILIPPINES

OWNER:
ATTY. FELIX S. ALICER

SHEET CONTENTS:

SECTIONS

DATE: JUNE 2025

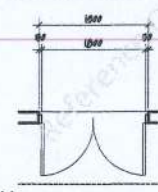
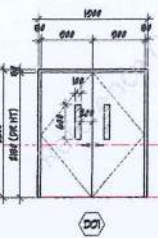
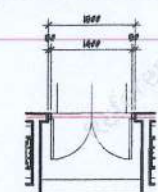
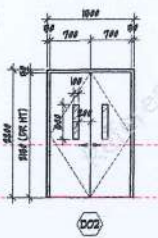
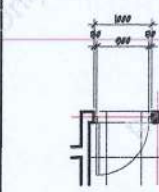
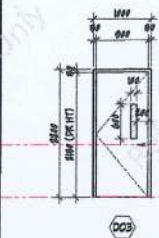
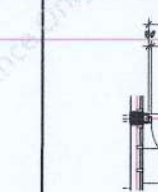
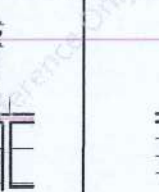
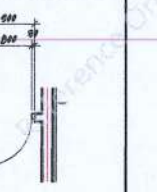
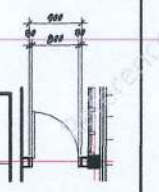
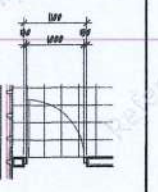
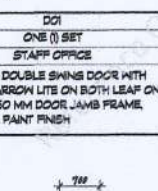
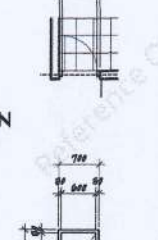
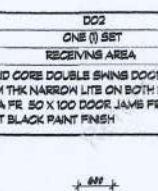
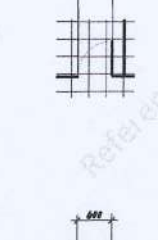
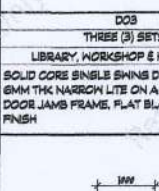
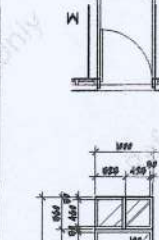
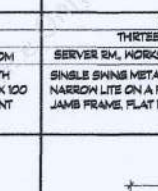
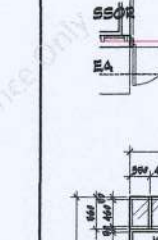
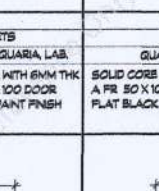
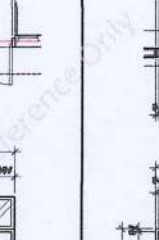
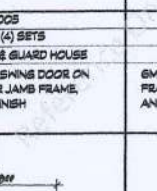
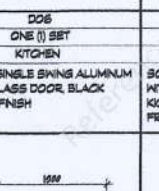
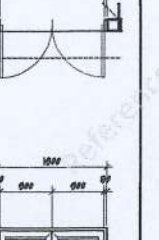
DRAWN BY: ETL CHECKED BY: PFAS

GRAPHIC SCALE:



SHEET NO.:

A-5

 PLAN  ELEV. D01 ONE (1) SET STAFF OFFICE SOLID CORE DOUBLE SWING DOOR WITH 6MM THK NARROW LITE ON BOTH LEAF ON A FR. 50 X 100 DOOR JAMB FRAME, FLAT BLACK PAINT FINISH	  D02 ONE (1) SET RECEIVING AREA SOLID CORE DOUBLE SWING DOOR WITH 6MM THK NARROW LITE ON BOTH LEAF ON A FR. 50 X 100 DOOR JAMB FRAME, FLAT BLACK PAINT FINISH	  D03 THREE (3) SETS LIBRARY, WORKSHOP & HOT ROOM SOLID CORE SINGLE SWING DOOR WITH 6MM THK NARROW LITE ON A FR. 50 X 100 DOOR JAMB FRAME, FLAT BLACK PAINT FINISH	  D04 THIRTEEN (13) SETS SERVER RM, WORKSHOP, AQUARIA, LAB. SINGLE SWING METAL DOOR WITH 6MM THK NARROW LITE ON A FR. 50 X 100 DOOR JAMB FRAME, FLAT BLACK PAINT FINISH	  D05 FOUR (4) SETS QUARTERS & GUARD HOUSE SOLID CORE SINGLE SWING DOOR ON A FR. 50 X 100 DOOR JAMB FRAME, FLAT BLACK PAINT FINISH	  D06 ONE (1) SET KITCHEN 6MM THK SINGLE SWING ALUMINUM FRAMED GLASS DOOR, BLACK ANODIZED FINISH	  D07 ONE (1) SET PWD TOILET SOLID CORE SINGLE SWING DOOR WITH 15 MM THK STAINLESS STEEL KICK PLATE ON 50 X 100 DOOR JAMB FRAME, FLAT BLACK PAINT FINISH	  D08 FOUR (4) SETS MALE/FEMALE TOILET SOLID CORE SINGLE SWING DOOR WITH 15 MM THK STAINLESS STEEL KICK PLATE ON 50 X 100 DOOR JAMB FRAME, FLAT BLACK PAINT FINISH
 PLAN  ELEV. D09 FIVE (5) SETS TBS @ QUARTERS & GUARDHOUSE HOLLOW CORE SINGLE SWING DOOR ON A FR. 50 X 100 DOOR JAMB FRAME, FLAT BLACK PAINT FINISH	  D10 FOUR (4) SETS SHOWER ROOM @ EQPT./DRYING AREA 12MM THK HIGH PRESSURE LAMINATE (VERIFY TYPE)	  D11 ONE (1) SET EQPT./DRYING AREA SOLID CORE SINGLE SWING DOOR WITH 6MM THK NARROW LITE ON A FR. 50 X 100 DOOR JAMB FRAME, FLAT BLACK PAINT FINISH	  D12 ONE (1) SET EQPT./DRYING AREA SOLID CORE SINGLE SWING DOOR WITH 6MM THK NARROW LITE ON A FR. 50 X 100 DOOR JAMB FRAME, FLAT BLACK PAINT FINISH	  D13 SIX (6) SETS LABORATORIES 6MM THK GLASS ALUMINUM FRAMED SLIDING DOOR, BLACK ANODIZED FINISH	  D14 ONE (1) SET GENSET & PUMP ROOM 50 X 100 X 15 MM THK LOUVERED STEEL DOUBLE SWING DOOR ON 50 X 100 STEEL JAMB, FLAT BLACK PAINT FINISH	  D15 TWO (2) SETS STORAGE & ELEC. RM. 50 X 100 X 15 MM THK LOUVERED STEEL DOUBLE SWING DOOR ON 50 X 100 STEEL JAMB, FLAT BLACK PAINT FINISH	NOTE: - VERIFY ACTUAL DIMENSIONS ON SITE PRIOR TO FABRICATION OF DOORS AND WINDOWS. - VERIFY GLASS THICKNESS W/ THE SUPPLIER AND/OR MANUFACTURER. - CONTRACTOR TO SUBMIT HOOK UP PRIOR TO FABRICATION OF DOORS AND WINDOWS.

PLAN ELEV. W01 TWO (2) SETS MALE QUARTERS & LIBRARY 6MM THK FROSTED GLASS FIXED WINDOW IN BLACK ANODIZED ALUMINUM FRAME	PLAN ELEV. W02 THREE (3) SETS KITCHEN & MESS HALL, FEMALE QUARTERS, AND PUBLIC TOILETS 6MM THK CLEAR GLASS ANNING WINDOW (TOP) AND BLACK FIXED ALUMINUM COMPOSITE PANELS (BOT) IN BLACK ANODIZED ALUMINUM FRAME	PLAN ELEV. W03 THREE (3) SETS FEMALE LOCKER ROOM, LAUNDRY & DRYING AREA 6MM THK CLEAR GLASS FIXED AND ANNING WINDOW IN BLACK ANODIZED ALUMINUM FRAME	PLAN ELEV. W04 TWO (2) SETS OFFICE AND LABORATORY 6MM THK CLEAR GLASS FIXED AND ANNING WINDOW IN BLACK ANODIZED ALUMINUM FRAME WITH ACU ENCLOSURE	PLAN ELEV. W05 ONE (1) SET LABORATORY WASHROOM 6MM THK CLEAR GLASS FIXED AND ANNING WINDOW IN BLACK ANODIZED ALUMINUM FRAME WITH ACU ENCLOSURE
PLAN ELEV. W06 THREE (3) SETS FEMALE QUARTERS, CHEM ROOM AND ANTE-ROOM 1 6MM THK CLEAR GLASS ANNING WINDOW IN BLACK ANODIZED ALUMINUM FRAME WITH FIXED BLACK ACP PANELS AND ACU ENCLOSURE	PLAN ELEV. W06A ONE (1) SET MALE QUARTERS 6MM THK CLEAR GLASS ANNING WINDOW IN BLACK ANODIZED ALUMINUM FRAME WITH FIXED BLACK ACP PANELS AND ACU ENCLOSURE	PLAN ELEV. W07 ONE (1) SET PHYCHEM LAB 6MM THK CLEAR GLASS FIXED AND ANNING WINDOW IN BLACK ANODIZED ALUMINUM FRAME WITH ACU ENCLOSURE	PLAN ELEV. W07A ONE (1) SET PHYCHEM LAB 6MM THK CLEAR GLASS FIXED AND ANNING WINDOW IN BLACK ANODIZED ALUMINUM FRAME WITH ACU ENCLOSURE	PLAN ELEV. W08 ONE (1) SET GUARDHOUSE 6MM THK CLEAR GLASS ANNING AND FIXED WINDOW (TOP) AND BLACK FIXED ALUMINUM COMPOSITE PANELS (BOT) IN BLACK ANODIZED ALUMINUM FRAME
PLAN ELEV. W09 TWO (2) SETS LABORATORY 6MM THK CLEAR GLASS ANNING AND FIXED WINDOW IN BLACK ANODIZED ALUMINUM FRAME WITH ACU ENCLOSURE	PLAN ELEV. W10 TWO (2) SETS PUBLIC TOILETS 6MM THK CLEAR GLASS ANNING AND FIXED WINDOW (TOP) AND BLACK FIXED ALUMINUM COMPOSITE PANELS (BOT) IN BLACK ANODIZED ALUMINUM FRAME	PLAN ELEV. W11 ONE (1) SET KITCHEN & MESS HALL 6MM THK CLEAR GLASS SINGLE HUNG WINDOW IN BLACK ANODIZED ALUMINUM FRAME	PLAN ELEV. W12 ONE (1) SET EQUIPMENT AREA 6MM THK CLEAR GLASS ANNING WITH FIXED WINDOW IN BLACK ANODIZED ALUMINUM FRAME	PLAN ELEV. W13 ONE (1) SET LIBRARY 6MM THK CLEAR GLASS ANNING WITH FIXED WINDOW IN BLACK ANODIZED ALUMINUM FRAME WITH ACU ENCLOSURE

1 DOORS & WINDOWS SCHEDULE
A-7A SCALE: 1/50 M

MSRS_Sarangani_p.9

JORGE YULO ARCHITECTS & ASSOCIATES

3rd Floor Automatic Center Bldg.
2357 Das Chino Reyes Ave. 20th,
Makati City, Philippines 1211
Telephone No. (02) 8870333
Fax No. (02) 8870374
E-Mail Address:
jorgeyulo@jorgeyulo.com
jyulo@jorgeyulo.com
URL Address:
http://www.jorgeyulo.com

PTF NO.: 10475571 REG. NO.: 12396
ISSUED ON: JAN 08, 2025 TPN NO.: 102-325-935

DESIGNED AT:
MANKATI CITY

JORGE MANUEL B. YULO
ARCHITECT

ENGINEER

PTF NO.: 10475571 REG. NO.: 12396
ISSUED ON: JAN 08, 2025 TPN NO.: 102-325-935

DESIGNED AT:
MANKATI CITY

PROJECT TITLE:
PROPOSED
MARINE SCIENTIFIC
RESEARCH
STATION

LOCATION:
LEBAKIN, BRGY. KAWAS,
ALABEL
SARANGANI,
PHILIPPINES

OWNER:

ATTY. FELIX S. ALICER

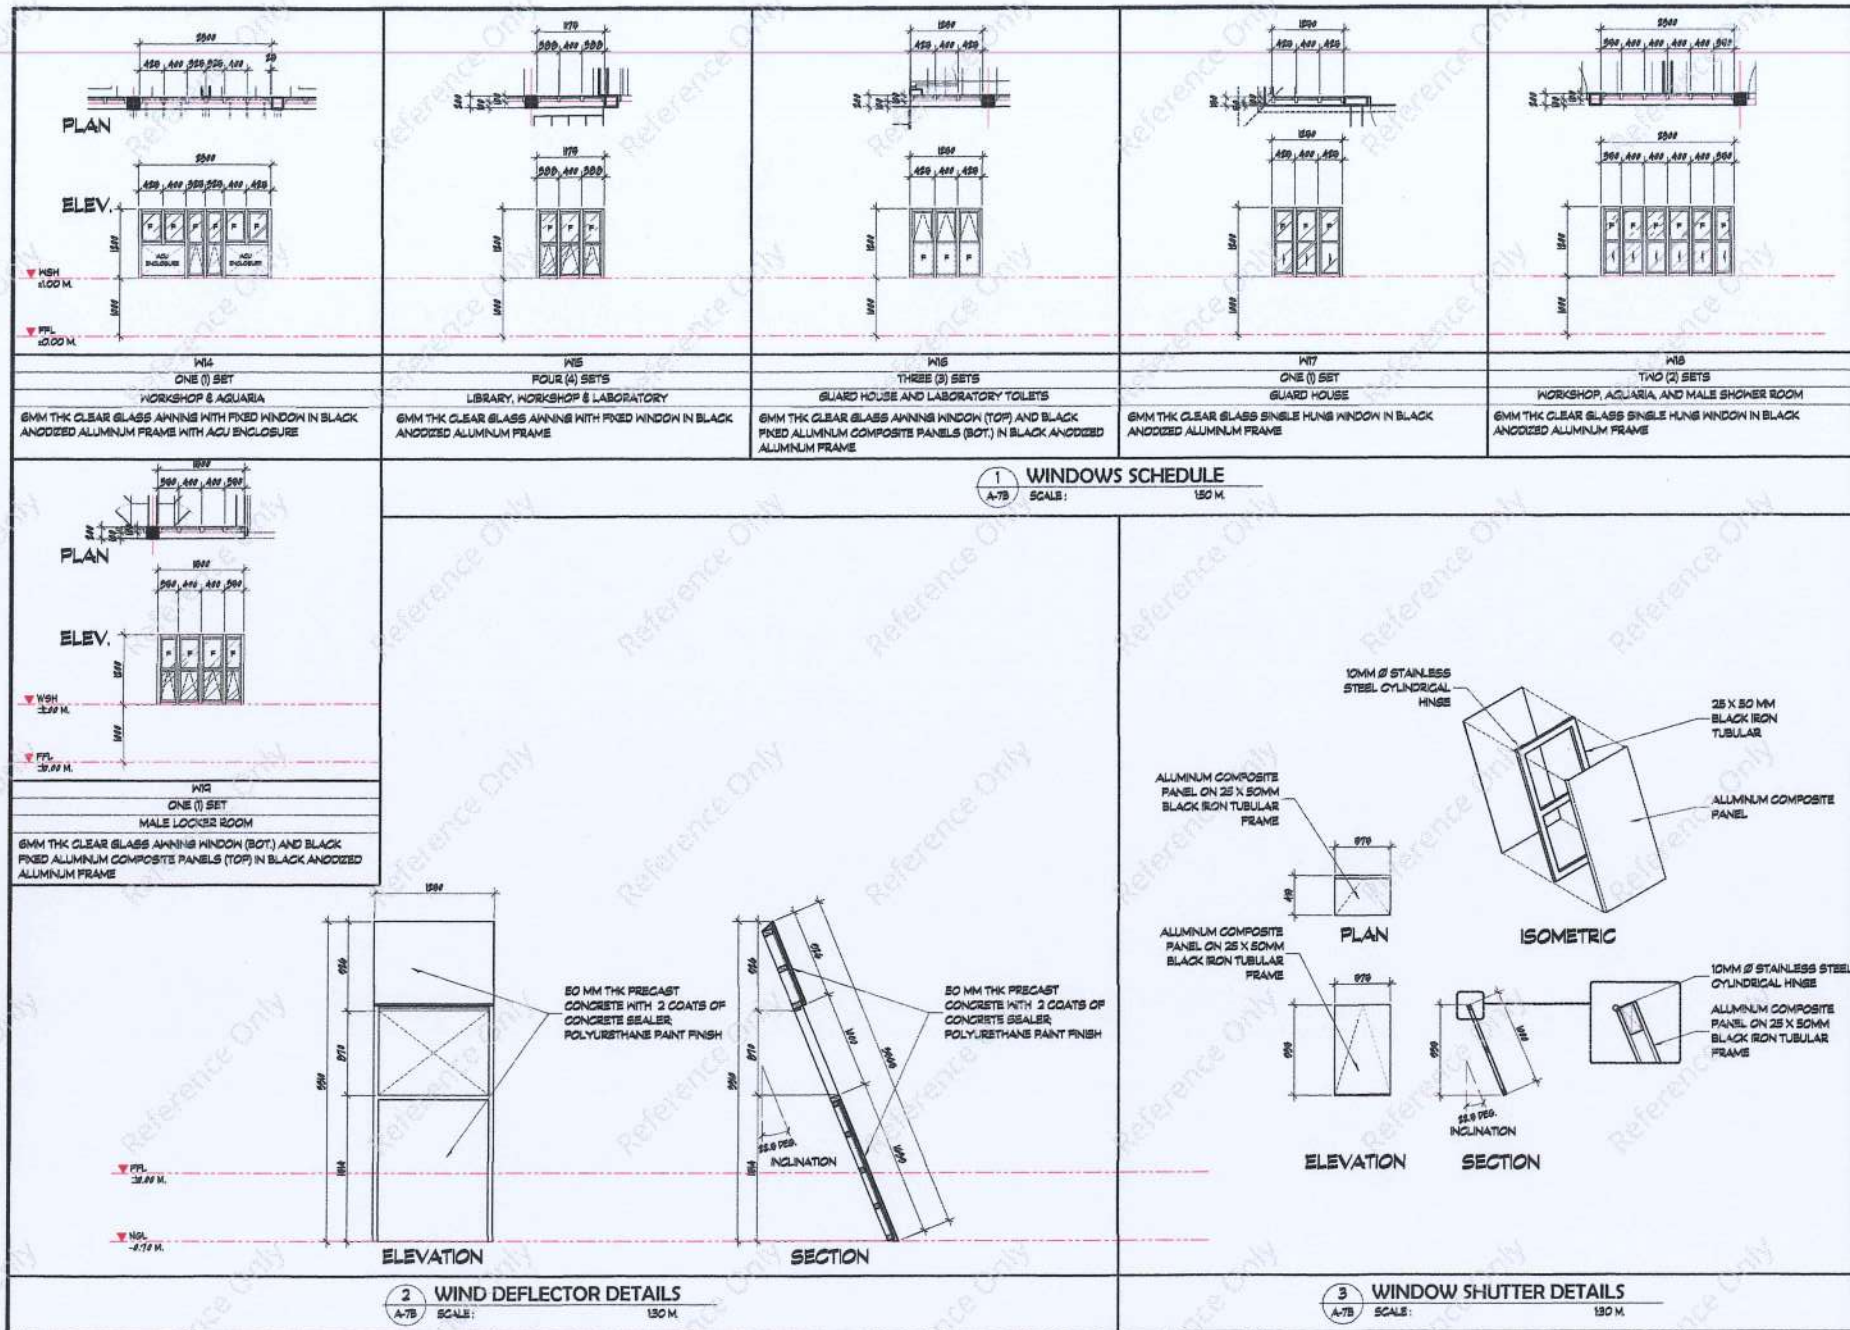
SHEET CONTENTS:
DOORS AND WINDOWS
SCHEDULE

DATE:
JUNE 2025
DRAWN BY:
ETL CHECKED BY:
MPAS

GRAPHIC SCALE:
1:50 METERS
1:100 METERS
1:150 METERS
1:200 METERS
1:250 METERS
1:300 METERS
1:350 METERS
1:400 METERS
1:450 METERS
1:500 METERS

SHEET NO.:

A-7A



JORGE YULO ARCHITECTS & ASSOCIATES

3rd Floor, Asean Center Bldg.
2207 Don Chino Rivera Ave. 8th,
Makati City, Philippines 1211
Telephone No. (82) 8482084
8482074
Fax No. (82) 8482074
Email Address: jyoarchitects@gmail.com
jyoarchitects@gmail.com
URL Address: http://www.jyloarchitects.com

PTX NO.: 10475571
REG. NO.: 12396
ISSUED ON: JAN 08, 2025
TIN NO.: 102-325-935
ISSUED AT: MAKATI CITY

JORGE MANUEL B. YULO
ARCHITECT

ENGINEER
PTX NO.:
REG. NO.:
ISSUED ON:
TIN NO.:
ISSUED AT:

PROJECT TITLE:
PROPOSED MARINE SCIENTIFIC RESEARCH STATION
LOCATION:
LEBAKIN, BRGY. KAWAS, ALABEL, SARANGANI, PHILIPPINES

OWNER:
ATTY. FELIX S. ALICER

SHEET CONTENTS:
WINDOWS SCHEDULE
WINDOW SHUTTER, AND DEFLECTOR DETAILS

DATE: JUNE 2025
DRAWN BY: ETL
CHECKED BY: RFAAS
GRAPHIC SCALE:
1:50 METERS
1:100 METERS
1:200 METERS
1:500 METERS
1:1000 METERS
1:2000 METERS

SHEET NO.:
A-7B



JORGE YULO ARCHITECTS & ASSOCIATES
3rd Floor Automatic Center Bldg.
2287 Quezon Avenue, 2nd Fl.,
Makati City, Philippines 1211
Telephone No. (817) 882334
Fax No. (817) 882374
Email Address: jyulo@jyulo.com
jyulo@jyulo.com
URL Address: <http://www.jyulo.com>

PRJ. NO.: 10475571 REG. NO.: 12396
ISSUED ON: JAN 08, 2025 TIN NO.: 102-325-935
DESIGNED AT: MAKATI CITY

JORGE MANUEL B. YULO
ARCHITECT

ENGINEER

PRJ. NO.: 10475571 REG. NO.: 12396
ISSUED ON: JAN 08, 2025 TIN NO.: 102-325-935
DESIGNED AT: MAKATI CITY

PROJECT TITLE:
PROPOSED MARINE SCIENTIFIC RESEARCH STATION

LOCATION:
LEBAKUN, BRGY. KAWAS, ALABEL, SARANGANI, PHILIPPINES

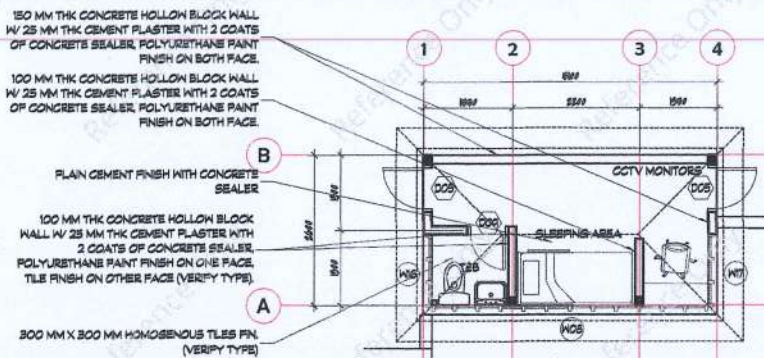
OWNER:
ATTY. FELIX S. ALICER

SHEET CONTENTS:
GUARD HOUSE AND GENSET ROOM DETAILS


DATE: JUNE 2025
DRAWN BY: ETL CHECKED BY: PFA3

GRAPHIC SCALE:
1:100 METERS
1:100 METERS
1:100 METERS
1:100 METERS


SHEET NO.:
A-9



FLOOR PLAN

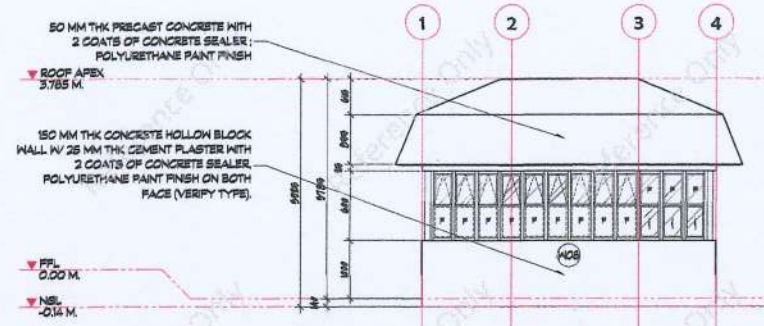


FRONT ELEVATION

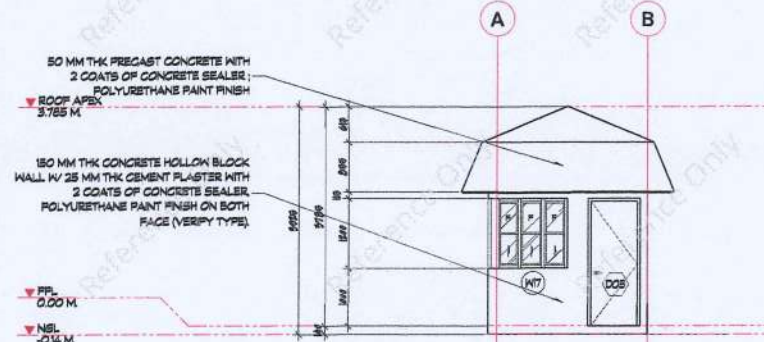


SIDE ELEVATION

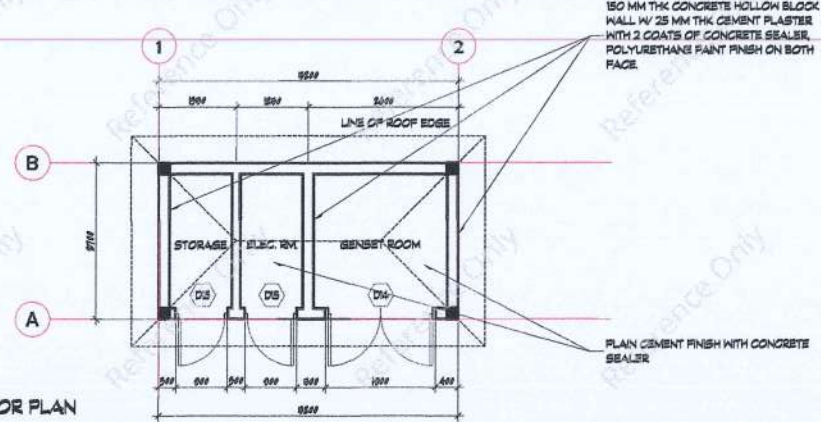
1 GUARD HOUSE DETAILS
SCALE: 1:50 M.



FLOOR PLAN

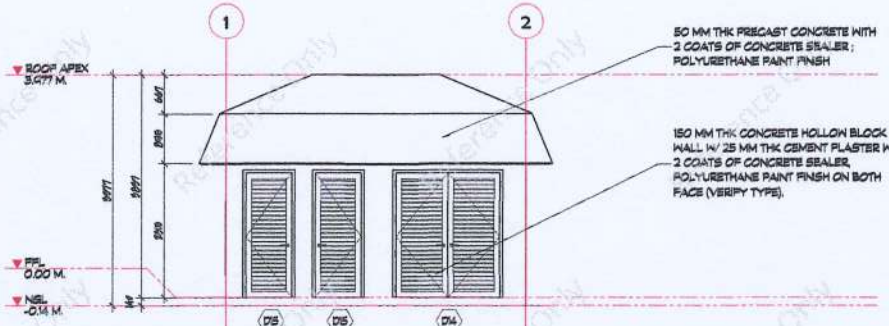

FRONT ELEVATION

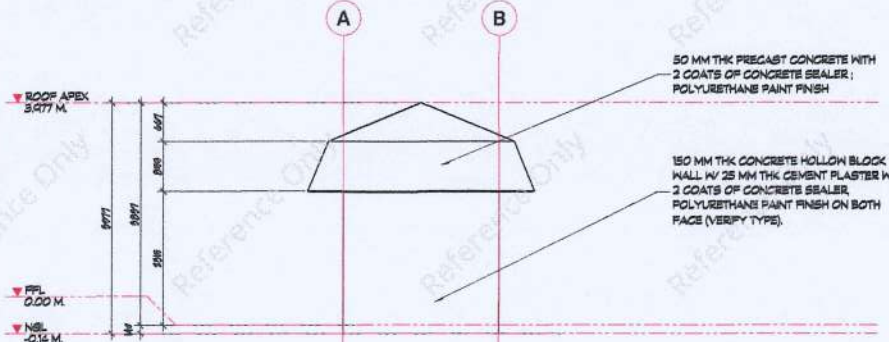

SIDE ELEVATION

2 GENSET ROOM DETAILS
SCALE: 1:50 M.